

SHEET	DESCRIPTION
A0.01	COVER SHEET
1 SERIES - PLANS	
A1.01	GENERAL PLAN
A1.02	SETOUT PLAN
A1.10	REFLECTED CEILING/POWER & DATA PLAN
2 SERIES - ELEVATIONS	
A2.01	ELEVATIONS SHEET 1
A2.02	ELEVATIONS SHEET 2
3 SERIES - DETAILS	
A3.01	JOINERY UNIT 1 - SHEET1
A3.02	JOINERY UNIT 1 - SHEET2
A3.03	JOINERY UNIT 1 - SHEET3
A3.10	JOINERY UNIT 2 - SHEET1
A3.11	JOINERY UNIT 2 - SHEET2
A3.20	BIRD WATCHING TABLE
A3.30	SHOWCASE SC A-04
A3.40	SPONSORSHIP PANEL
A3.50	TOUCH TABLE

DESIGNERS



Cunningham Martyn Design P.L.
18 Willis Street Richmond
Victoria 3121 Australia
Telephone 03 9428 2777
Facsimile 03 9428 2312
E-mail office@cmdesign.com.au
ACN 067 622 315

CONSULTANTS

REVISIONS		
DATE	REV NO.	DETAILS
15.11.07	T1	FOR TENDER

CLIENT
MELBOURNE WATER

PROJECT
EDITHVALE-SEAFORD WETLANDS DISCOVERY CENTRE

DRAWING TITLE
COVER SHEET


DATE	DRAWN BY
NOV. 07	CT
JOB NUMBER	
AS SHOWN @A3	EW 7199

ALL DIMENSIONS IN MILLIMETRES. WORK TO FIGURED DIMENSIONS ONLY. DO NOT USE SCALED DIMENSIONS. CHECK ALL DIMENSIONS ON SITE AND REPORT ALL DISCREPANCIES TO THE DESIGNERS BEFORE PROCEEDING WITH WORK.

DRAWING NUMBER

A0.01

CAD FILE	ISSUE
-	T1

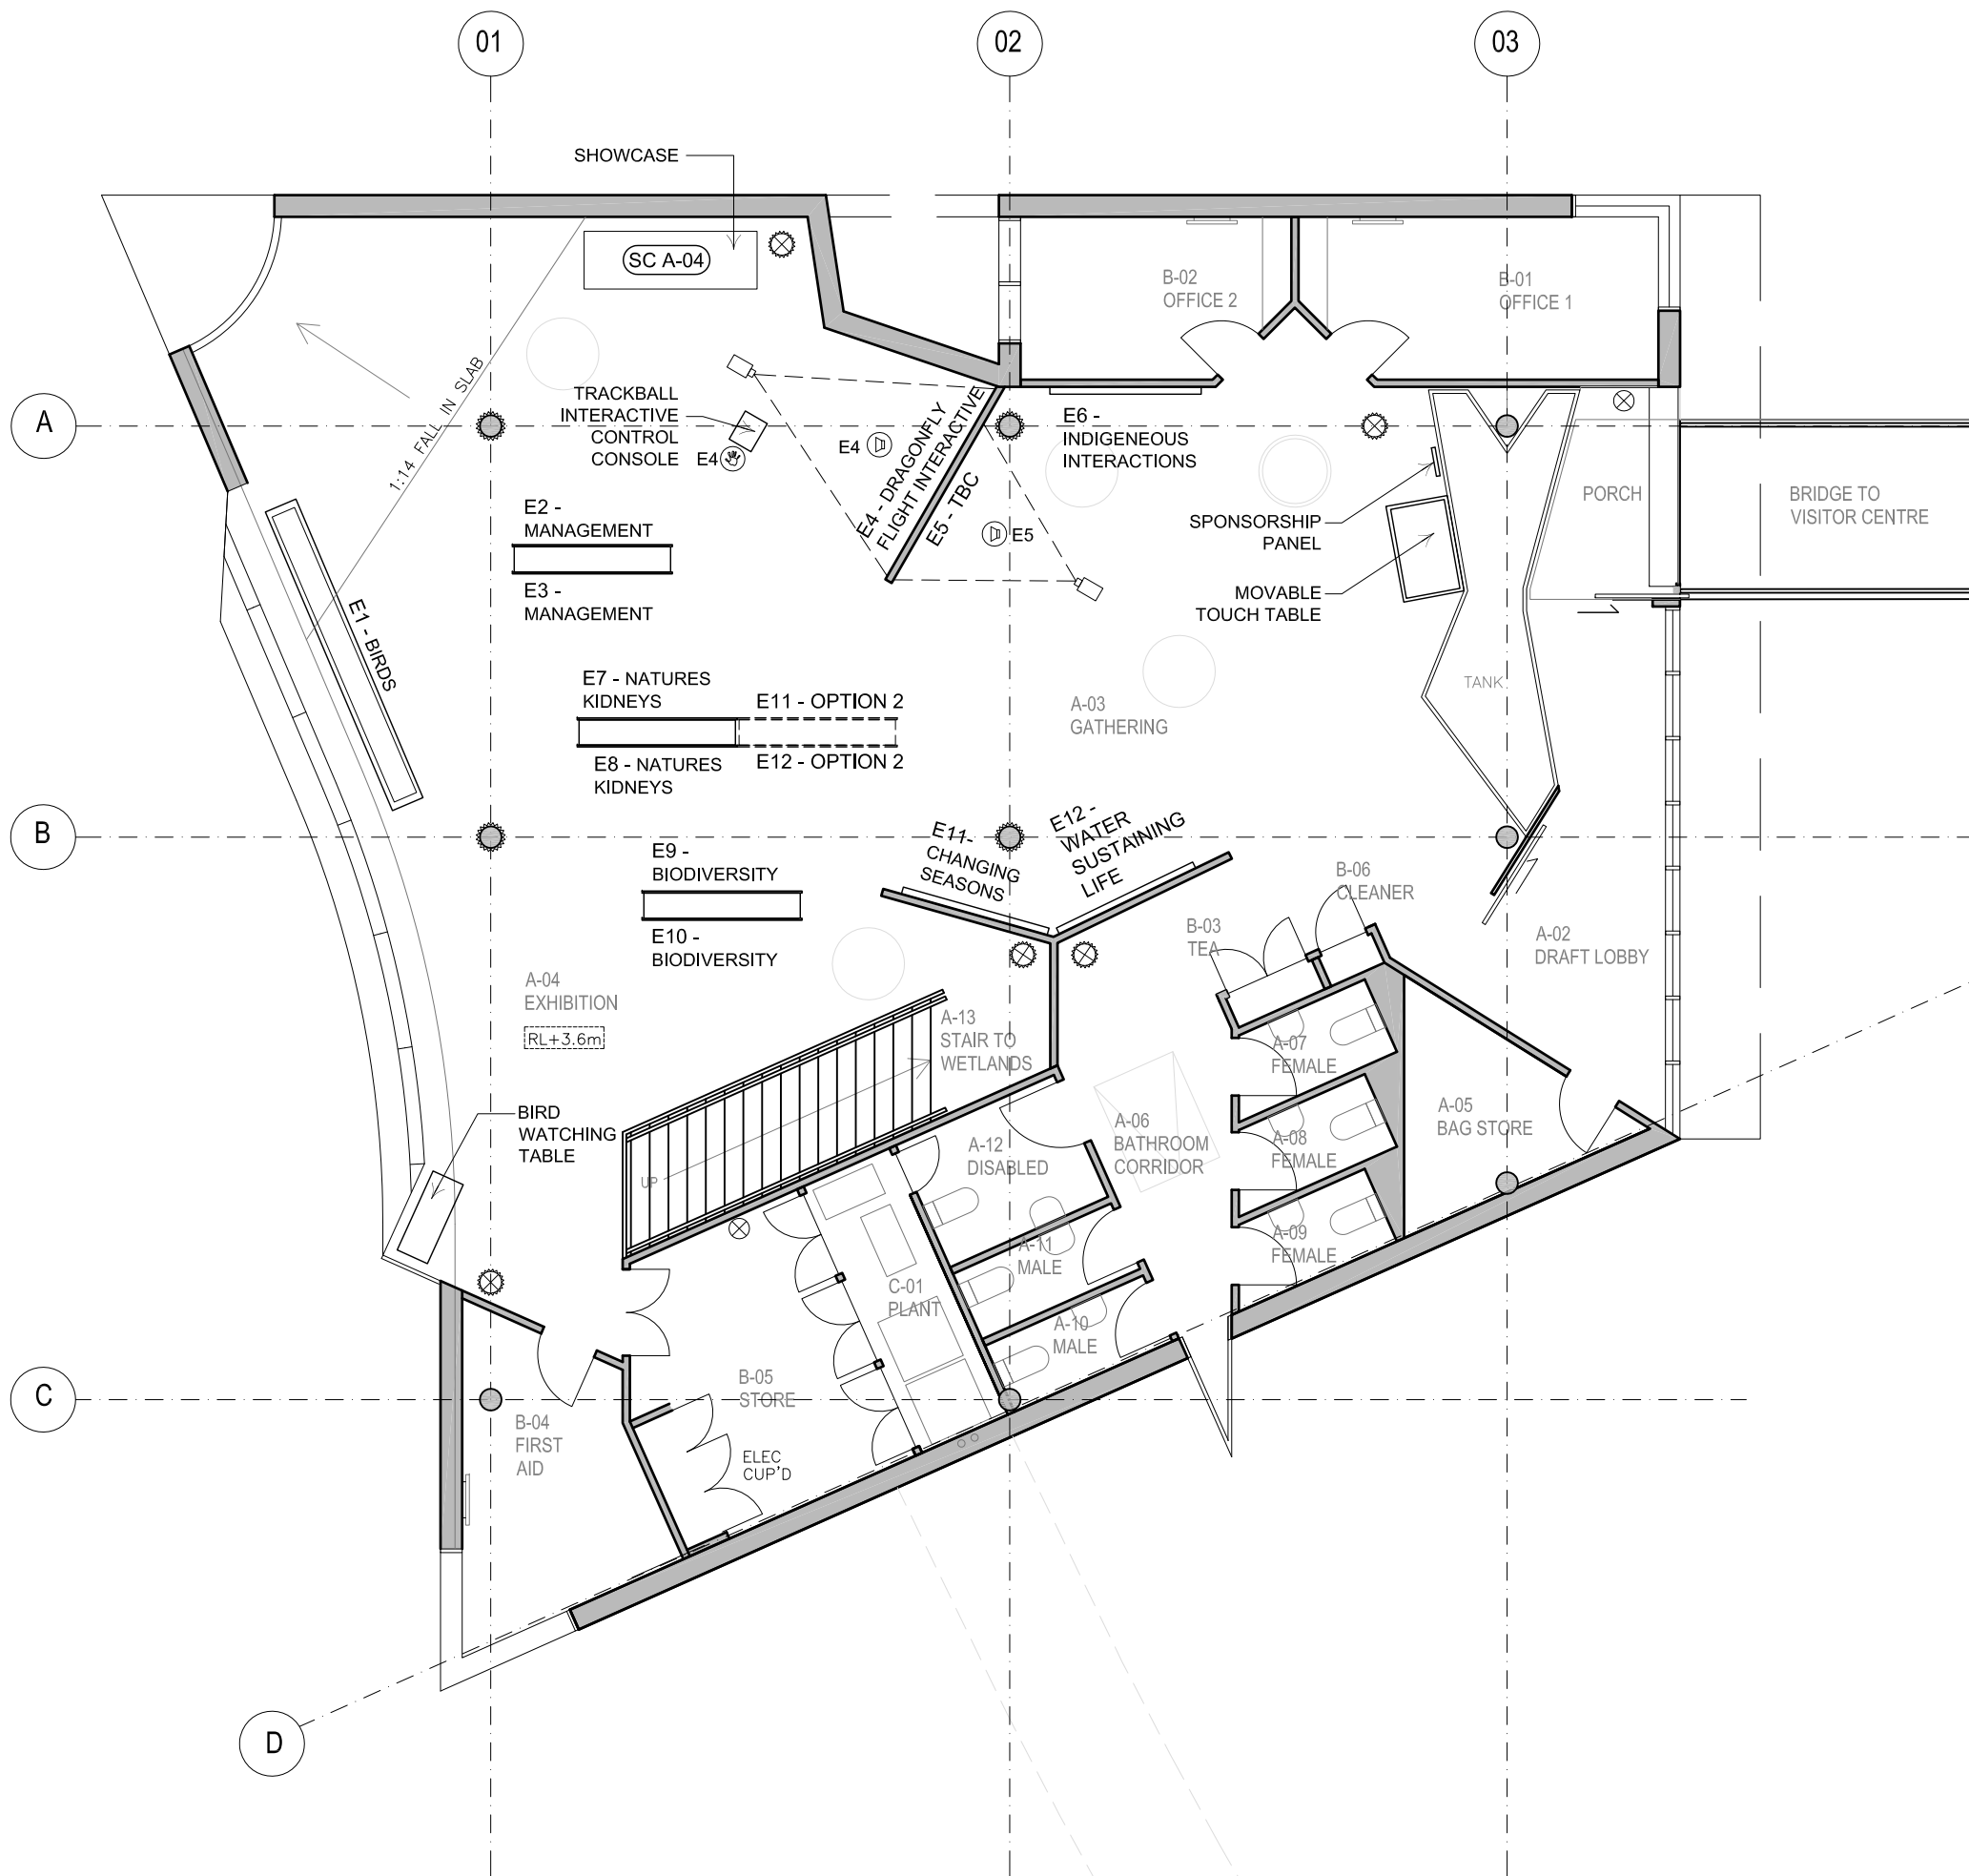

01 FLOOR PLAN
1:100

DESIGNERS

CMD
Cunningham Martyn Design P.L.
18 Willis Street Richmond
Victoria 3121 Australia
Telephone 03 9428 2777
Facsimile 03 9428 2312
E-mail office@cmdesign.com.au
ACN 067 622 315

CONSULTANTS

REVISIONS

DATE	REV NO.	DETAILS
15.11.07	T1	FOR TENDER

CLIENT

MELBOURNE WATER

PROJECT

EDITHVALE-SEAFORD WETLANDS
DISCOVERY CENTRE

DRAWING TITLE

FLOOR PLAN

DATE

NOV. 07

DRAWN BY

CT

JOB NUMBER

AS SHOWN @A3

EW 7199

ALL DIMENSIONS IN MILLIMETRES. WORK TO
FIGURED DIMENSIONS ONLY. DO NOT USE
SCALED DIMENSIONS. CHECK ALL DIMENSIONS ON
SITE AND REPORT ALL DISCREPANCIES TO THE
DESIGNERS BEFORE PROCEEDING WITH WORK.


DRAWING NUMBER

A1.01

CAD FILE

ISSUE

T1

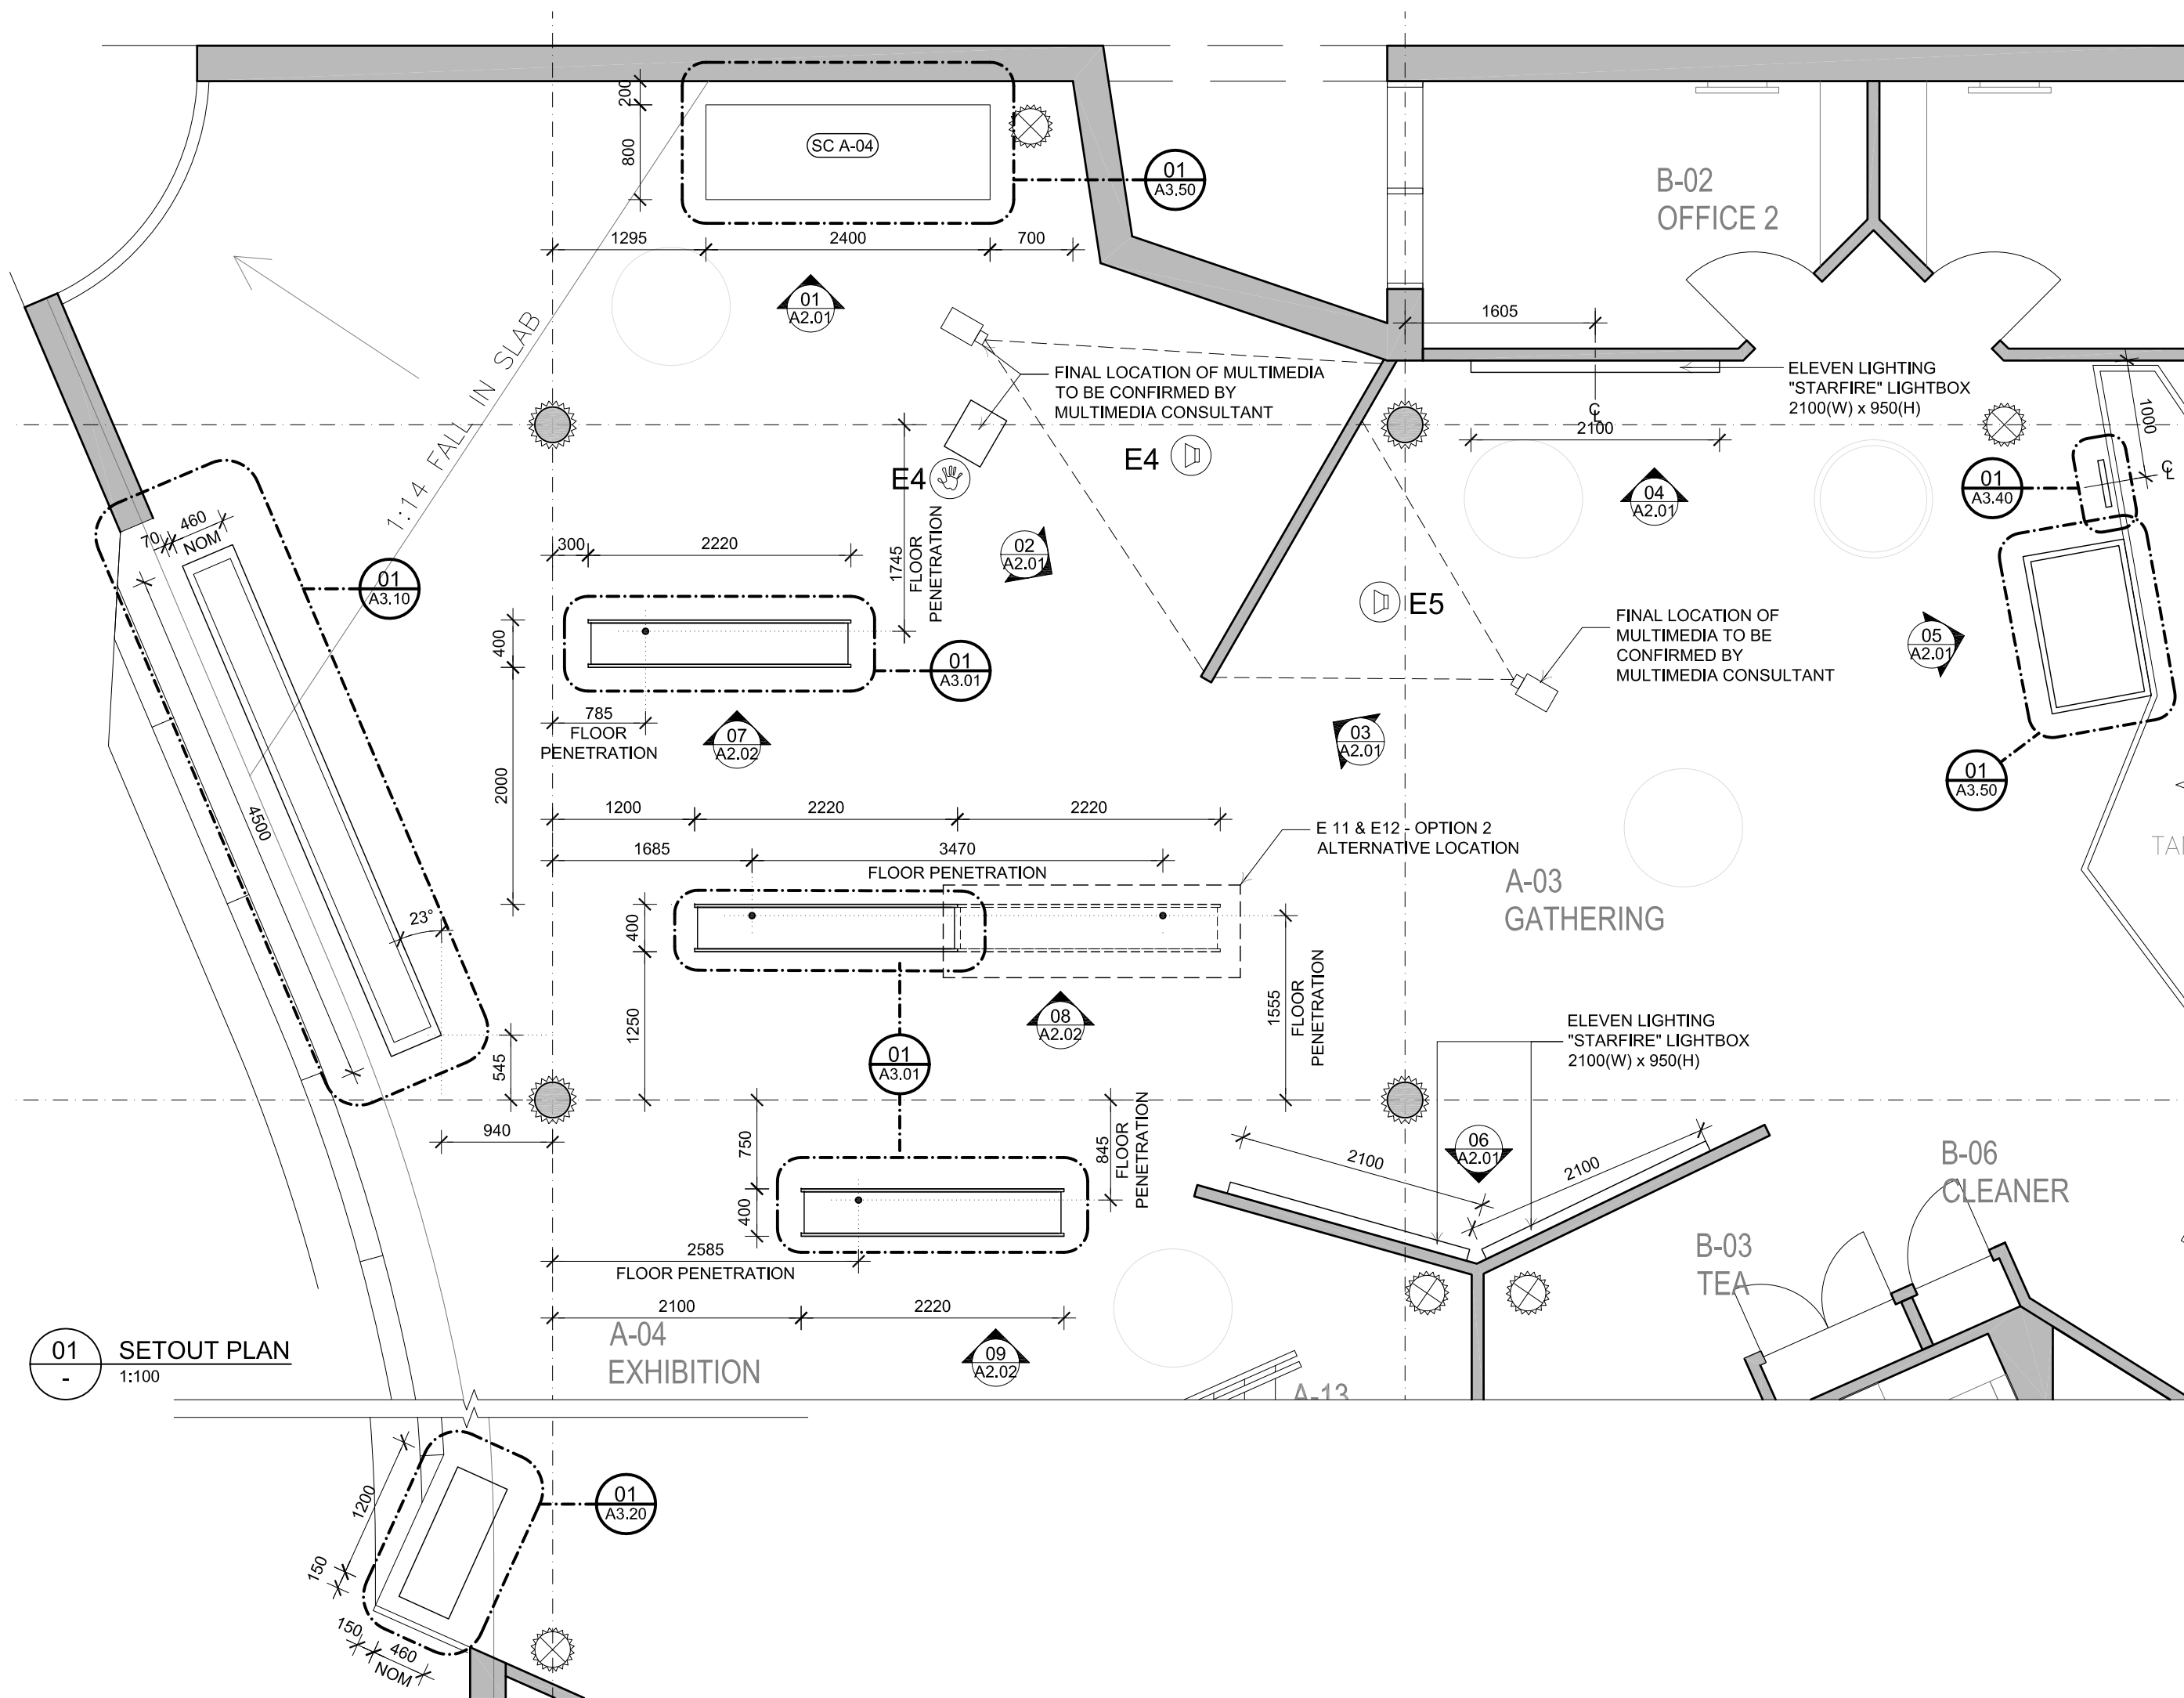

DESIGNERS

CMD
Cunningham Martyn Design P.L.
18 Willis Street Richmond
Victoria 3121 Australia
Telephone 03 9428 2777
Facsimile 03 9428 2312
E-mail office@cmdesign.com.au
ACN 067 622 315

CONSULTANTS

REVISIONS

DATE	REV NO.	DETAILS
15.11.07	T1	FOR TENDER

CLIENT

MELBOURNE WATER

PROJECT

EDITHVALE-SEAFORD WETLANDS
DISCOVERY CENTRE

DRAWING TITLE

SETOUT PLAN

DATE

NOV. 07

DRAWN BY

CT

JOB NUMBER

AS SHOWN @A3 EW 7199

DRAWING NUMBER


A1.02

CAD FILE

ISSUE

-

T1

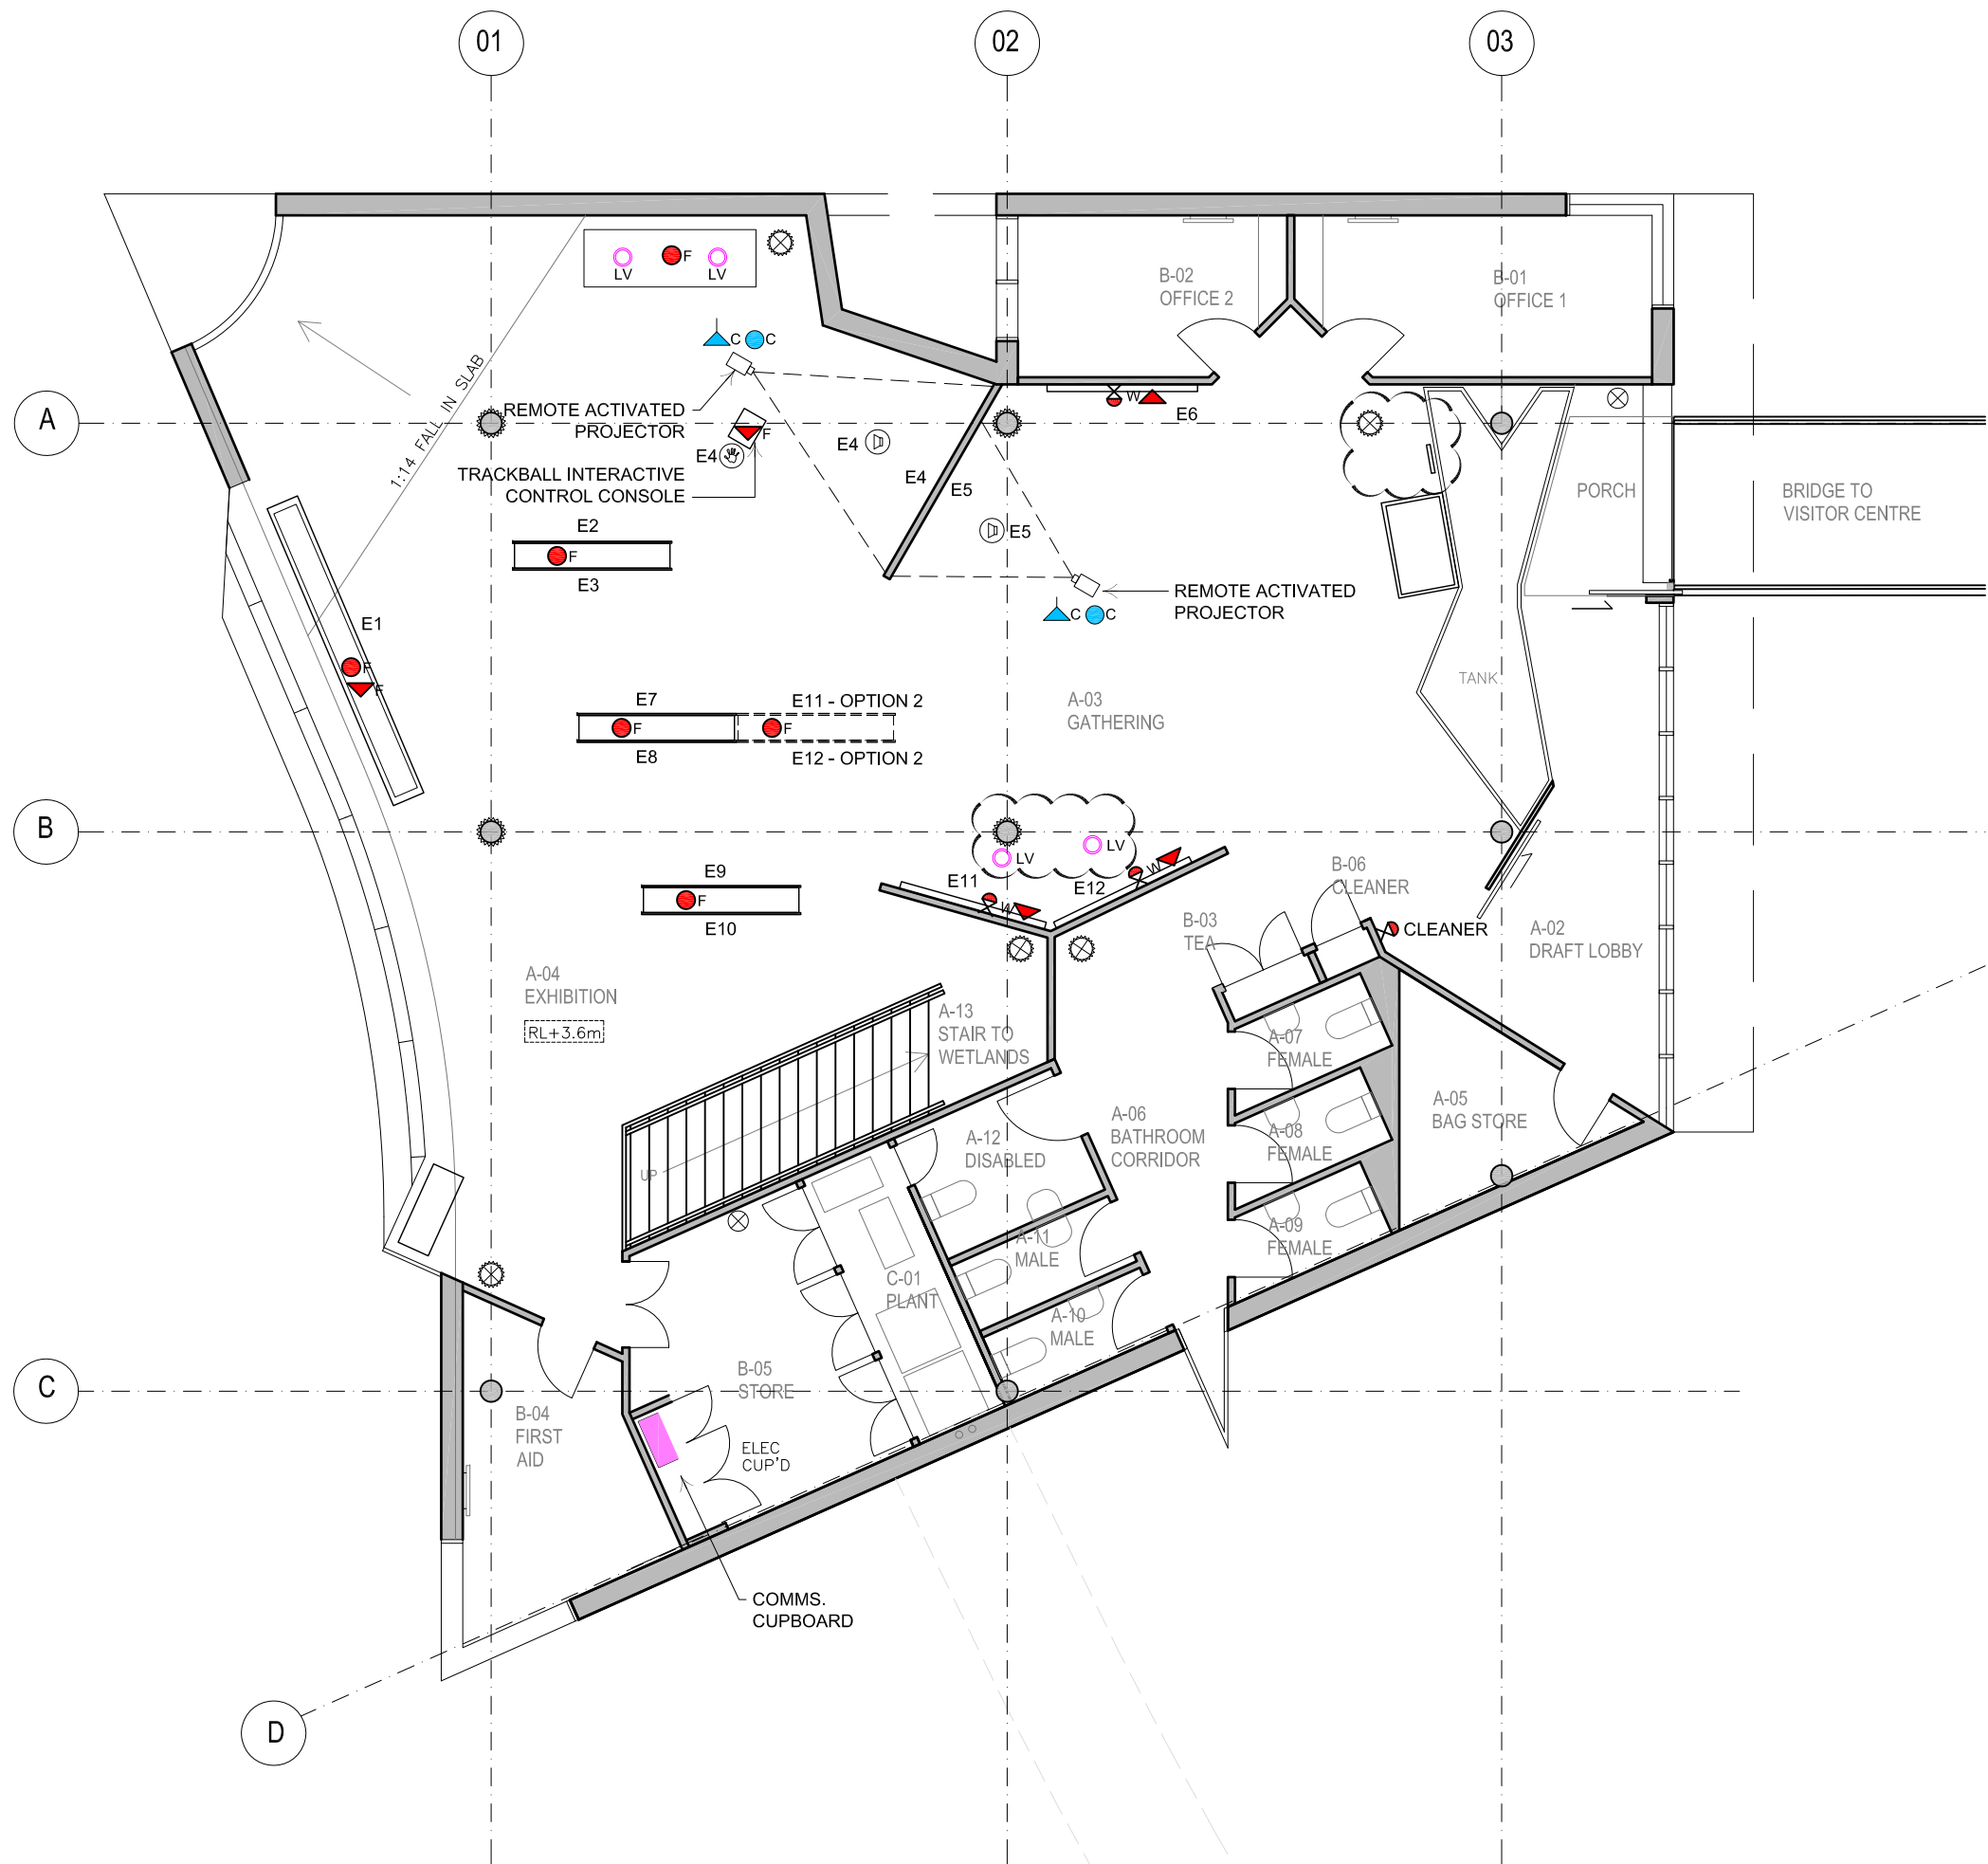

LEGEND

F FLOOR BOXES -
FLOOR DOUBLE POWER OUTLET & FLOOR TWIN (2X)
CAT6 DATA CIRCUITS RETICULATED THROUGH
FLOOR SLAB PENTRATION AND/OR FLOOR TRENCH.
FINAL LOCATION OF FLOOR PENETRATION AS PER
SETOUT. FINAL LOCATION OF FLOOR PENETRATION
TBC BACK TO COMMS. CUPBOARD
REFER TO ELECTRICAL CONSULTANT DRAWINGS

W WALL MOUNTED DOUBLE GPO.
REFER TO ELECTRICAL CONSULTANT DRAWINGS

W WALL MOUNTED TWIN (2X CAT6 DATA CIRCUITS
REFER TO ELECTRICAL CONSULTANT DRAWINGS

C CEILING DOUBLE POWER OUTLET.
REFER TO ELECTRICAL CONSULTANT DRAWINGS

C CEILING TWIN (2X CAT6 DATA CIRCUITS)
RETICULATED BACK TO COMMS. CUPBOARD
REFER TO ELECTRICAL CONSULTANT DRAWINGS

RECESSED DIRECTIONAL SPOTLIGHT -
SPECIFICATION TBC.
REFER TO ELECTRICAL CONSULTANT DRAWINGS

UNLESS OTHERWISE NOTED ALL POWER AND
DATA CIRCUITS TO BE RUN BACK TO COMMS
ROOM.

ALL FITTINGS, FIXTURES AND HARDWARE AT
CEILING HEIGHT IS TO BE SUPPLIED AS OR
PAINTED BLACK.

DESIGNERS

CMD
Cunningham Martyn Design P.L.
18 Willis Street Richmond
Victoria 3121 Australia
Telephone 03 9428 2777
Facsimile 03 9428 2312
E-mail office@cmdesign.com.au
ACN 067 622 315

CONSULTANTS

REVISIONS

DATE	REV NO.	DETAILS
15.11.07	T1	FOR TENDER
06.12.07	T2	REVISED TENDER

C LIENT

MELBOURNE WATER

PROJECT

EDITHVALE-SEAFORD WETLANDS
DISCOVERY CENTRE

DRAWING TITLE

REFLECTED CEILING PLAN
POWER & DATA PLAN

DATE

NOV. 07

DRAWN BY


CT

AS SHOWN @A3


EW 7199

ALL DIMENSIONS IN MILLIMETRES. WORK TO
FIGURED DIMENSIONS ONLY. DO NOT USE
SCALED DIMENSIONS. CHECK ALL DIMENSIONS ON
SITE AND REPORT ALL DISCREPANCIES TO THE
DESIGNERS BEFORE PROCEEDING WITH WORK.


DRAWING NUMBER

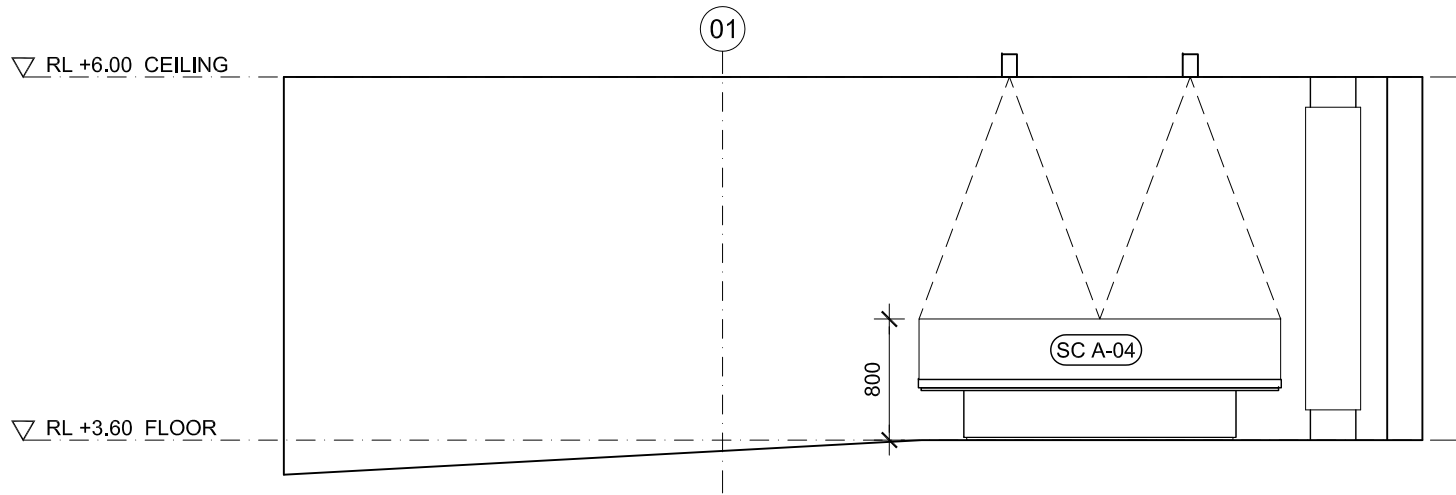


01 ELEVATION
A1.02 1:100

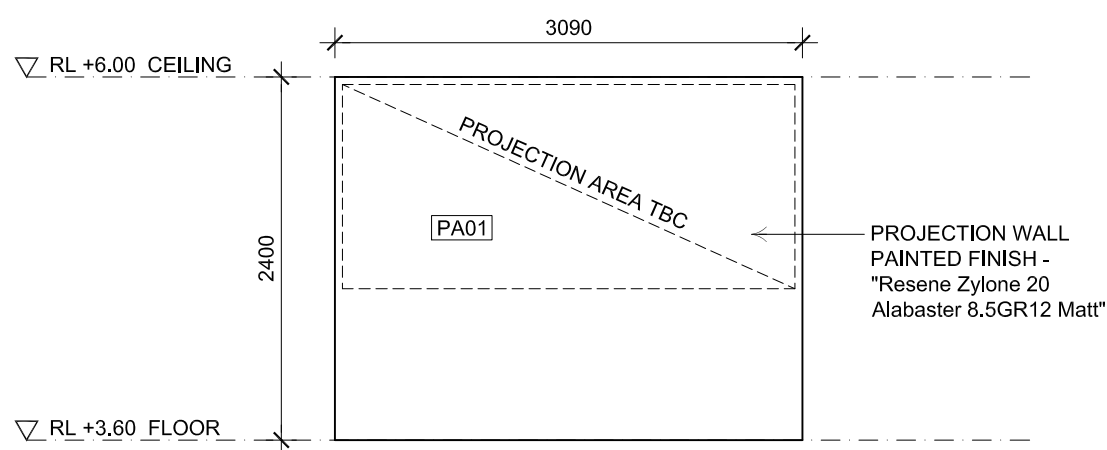


02 ELEVATION
A1.02 1:100

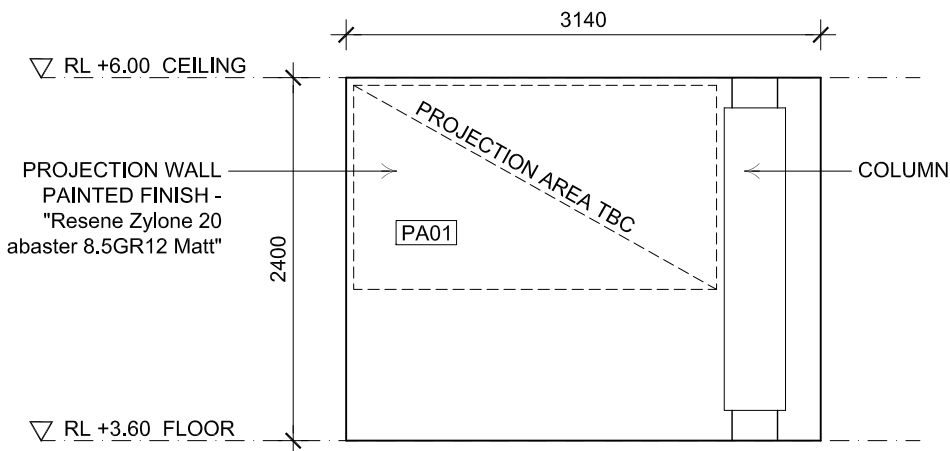


03 ELEVATION
A1.02 1:100

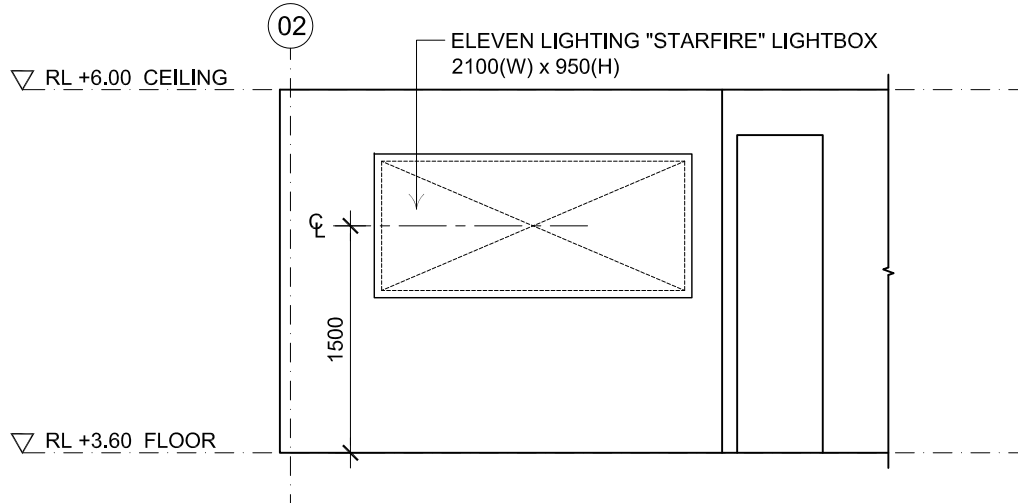

04 ELEVATION
A1.02 1:100

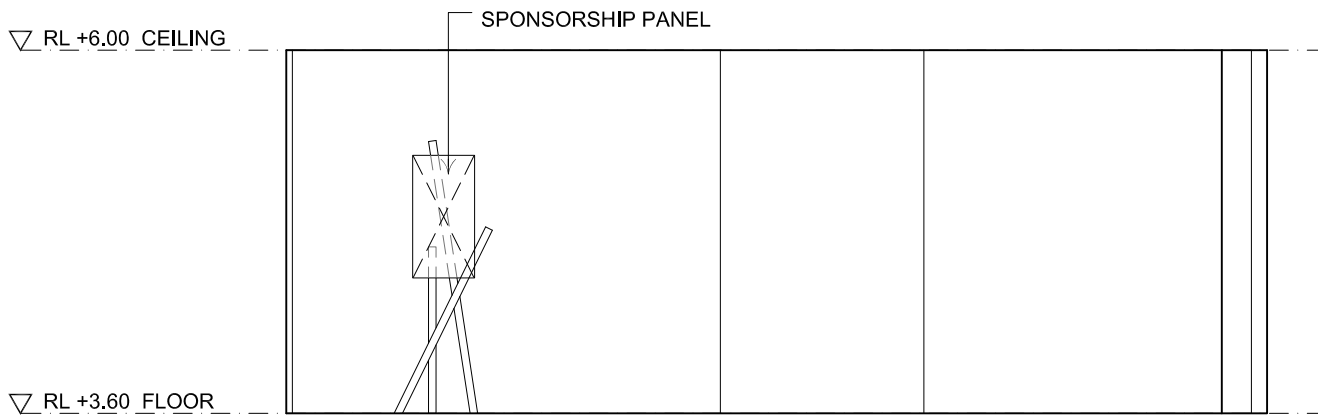

05 ELEVATION
A1.02 1:100

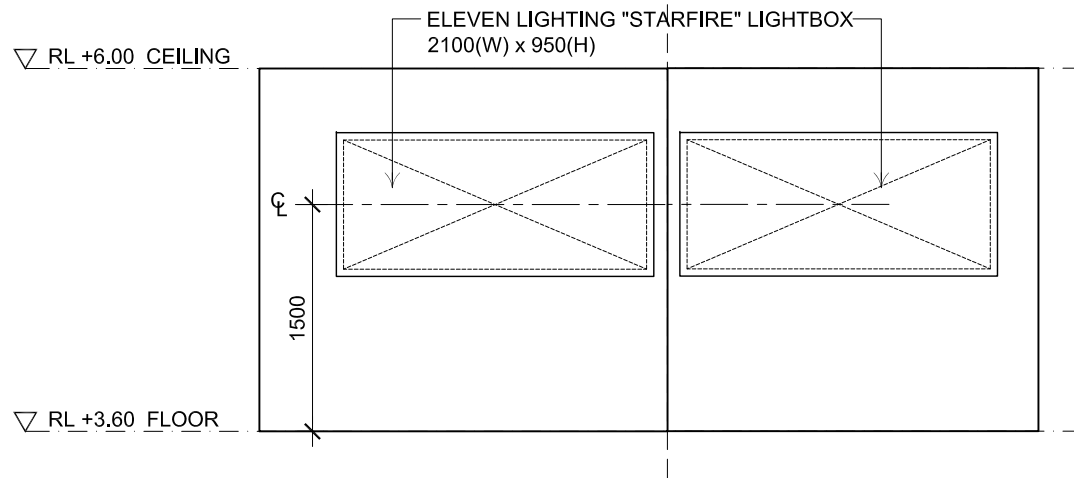

06 ELEVATION
A1.02 1:100

DESIGNERS

CMD
Cunningham Martyn Design P.L.
18 Willis Street Richmond
Victoria 3121 Australia
Telephone 03 9428 2777
Facsimile 03 9428 2312
E-mail office@cmdesign.com.au
ACN 067 622 315

CONSULTANTS

REVISIONS

DATE	REV NO.	DETAILS
15.11.07	T1	FOR TENDER

CLIENT

MELBOURNE WATER

PROJECT

EDITHVALE-SEAFORD WETLANDS
DISCOVERY CENTRE

DRAWING TITLE

ELEVATIONS

DATE

NOV. 07

DRAWN BY

CT

JOB NUMBER

AS SHOWN @A3

EW 7199

DRAWING NUMBER




A2.01

CAD FILE

ISSUE

-

P1

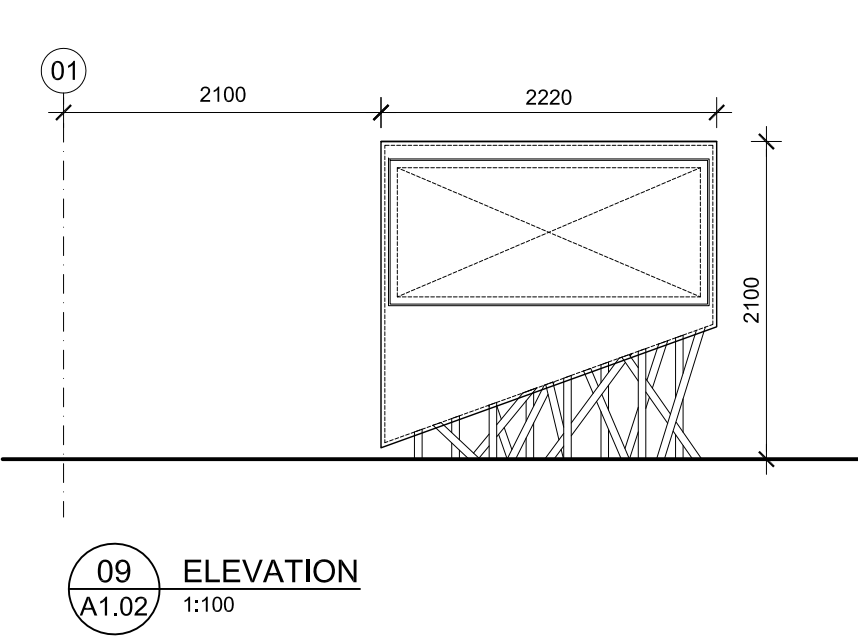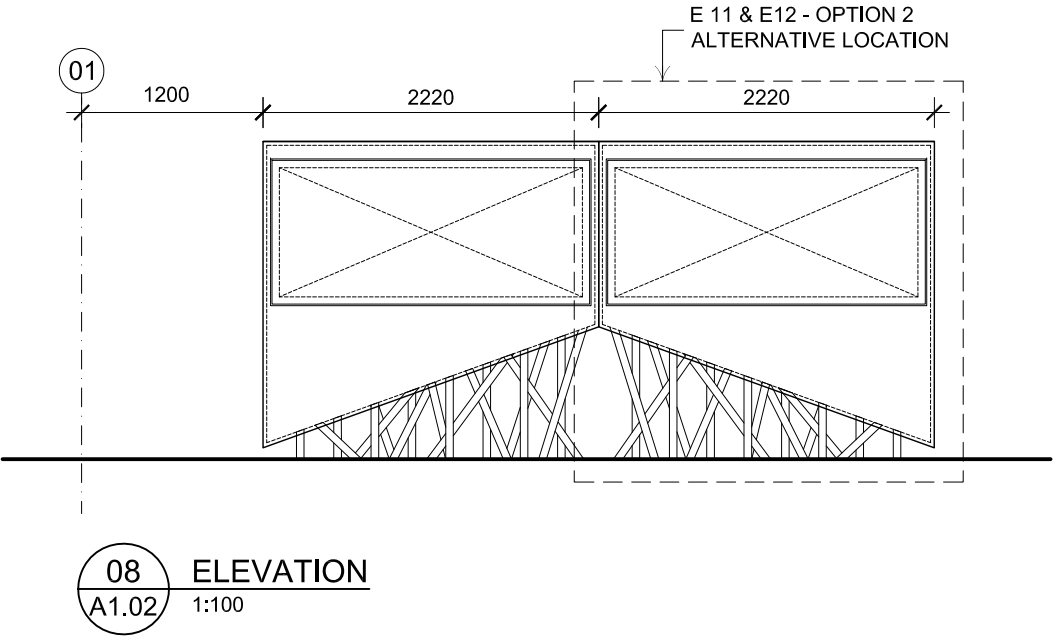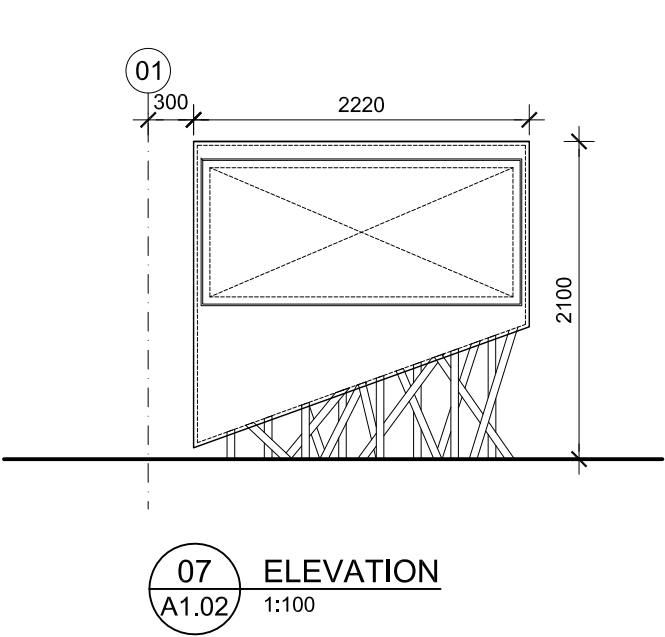

DESIGNERS

CMD Cunningham Martyn Design P.L.
18 Willis Street Richmond
Victoria 3121 Australia
Telephone 03 9428 2777
Facsimile 03 9428 2312
E-mail office@cmdesign.com.au
ACN 067 622 315

CONSULTANTS

REVISIONS

DATE	REV NO.	DETAILS
15.11.07	T1	FOR TENDER

CLIENT

MELBOURNE WATER

PROJECT

EDITHVALE-SEAFORD WETLANDS
DISCOVERY CENTRE

DRAWING TITLE

ELEVATIONS

DATE

NOV. 07

DRAWN BY

CT

JOB NUMBER

AS SHOWN @A3 EW 7199

ALL DIMENSIONS IN MILLIMETRES. WORK TO
FIGURED DIMENSIONS ONLY. DO NOT USE
SCALED DIMENSIONS. CHECK ALL DIMENSIONS ON
SITE AND REPORT ALL DISCREPANCIES TO THE
DESIGNERS BEFORE PROCEEDING WITH WORK.

DRAWING NUMBER


A2.02

CAD FILE




-

ISSUE

T1

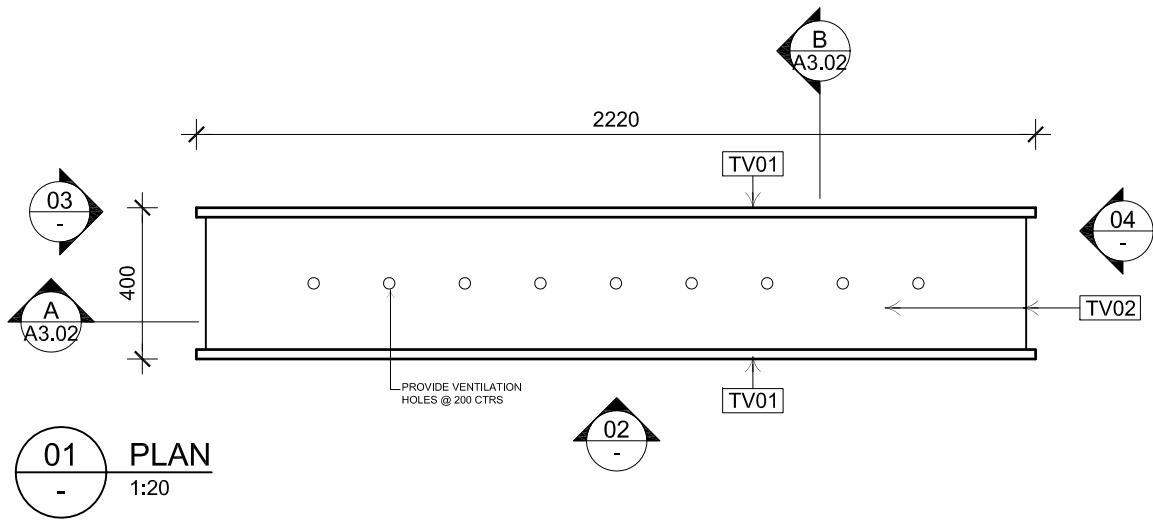

CODE	FINISH TYPE	FINISH	SUPPLIER
AA01	ANODISED ALUMINIUM	Exterior range pistachio matt m6683	Sapphire 02 4340 4333 Melb: Ian Rothwell 0438 427 555
PA01	PROJECTION SCREEN	Resene zylone 20 alabaster 8.5gr12 matt	Resene 1800 738 383
SS01	STAINLESS STEEL	STAINLESS STEEL	
TV01	TIMBER MULTIPLY	Eco-Core European Birch Multi-layer Plywood. End grain to match facing of TV02 Cabot's Natural Stain Fern Green with Cabot's Crystal Clear Satin finishing coats	Global Ventures Australia / Eco-Core 02 9652 0187
TV02	TIMBER MULTIPLY	Structural Veneer Lumber (SVL) Birch Multi-layer end grain faced board. Face grain to match end grain of TV01 Cabot's Natural Stain Fern Green with Cabot's Crystal Clear Satin finishing coats	Global Ventures Australia / Eco-Core 02 9652 0187
TV03	TIMBER FLEXIPLY	Bending plywood, European birch multi-layer plywood End grain to match facing of TV02. Cabot's Natural Stain Fern Green with Cabot's Crystal Clear Satin finishing coats	Global Ventures Australia / Eco-Core 02 9652 0187

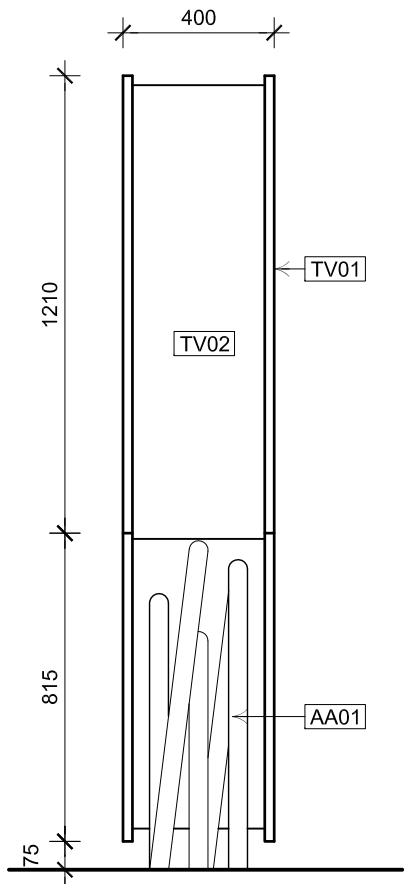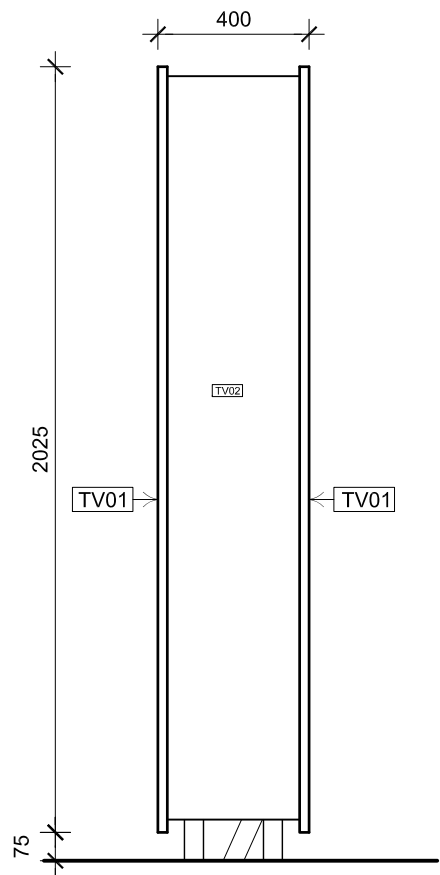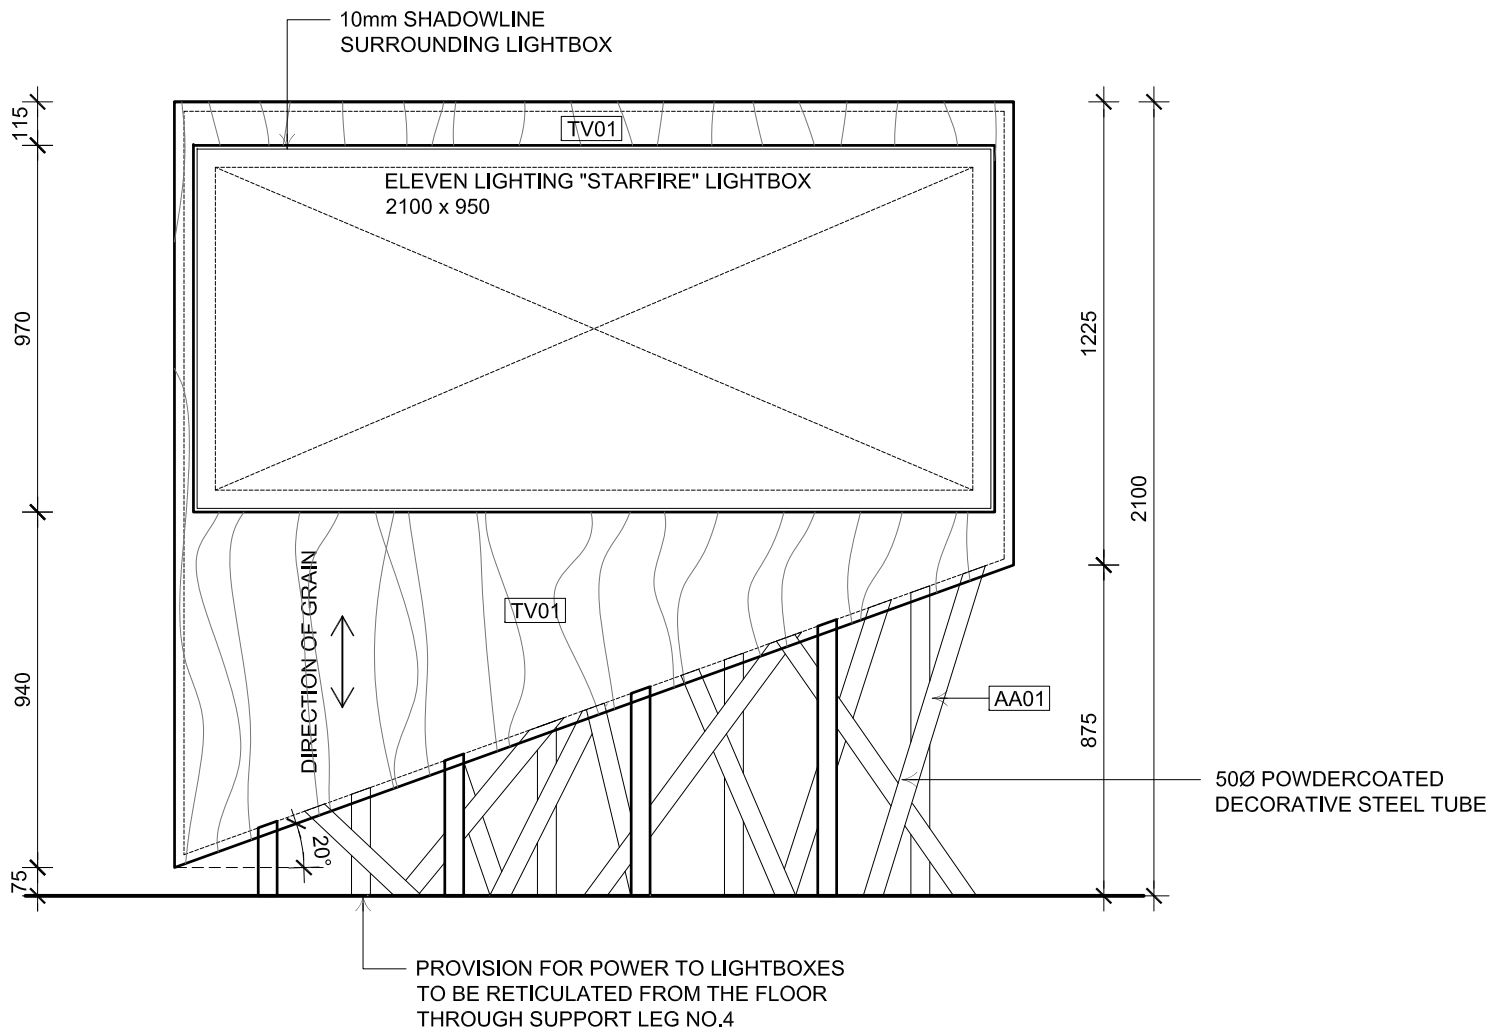

DESIGNERS

CMD
Cunningham Martyn Design P.L.
18 Willis Street Richmond
Victoria 3121 Australia
Telephone 03 9428 2777
Facsimile 03 9428 2312
E-mail office@cmdesign.com.au
ACN 067 622 315

CONSULTANTS

REVISIONS

DATE	REV NO.	DETAILS
15.11.07	T1	FOR TENDER

CLIENT

MELBOURNE WATER

PROJECT

EDITHVALE-SEAFORD WETLANDS
DISCOVERY CENTRE

DRAWING TITLE

JOINERY UNIT 1
SHEET 1

DATE

NOV. 07

DRAWN BY

CT

JOB NUMBER

AS SHOWN @A3

EW 7199

ALL DIMENSIONS IN MILLIMETRES. WORK TO
FIGURED DIMENSIONS ONLY. DO NOT USE
SCALED DIMENSIONS. CHECK ALL DIMENSIONS ON
SITE AND REPORT ALL DISCREPANCIES TO THE
DESIGNERS BEFORE PROCEEDING WITH WORK.

DRAWING NUMBER


A3.01

CAD FILE


ISSUE

-

T1

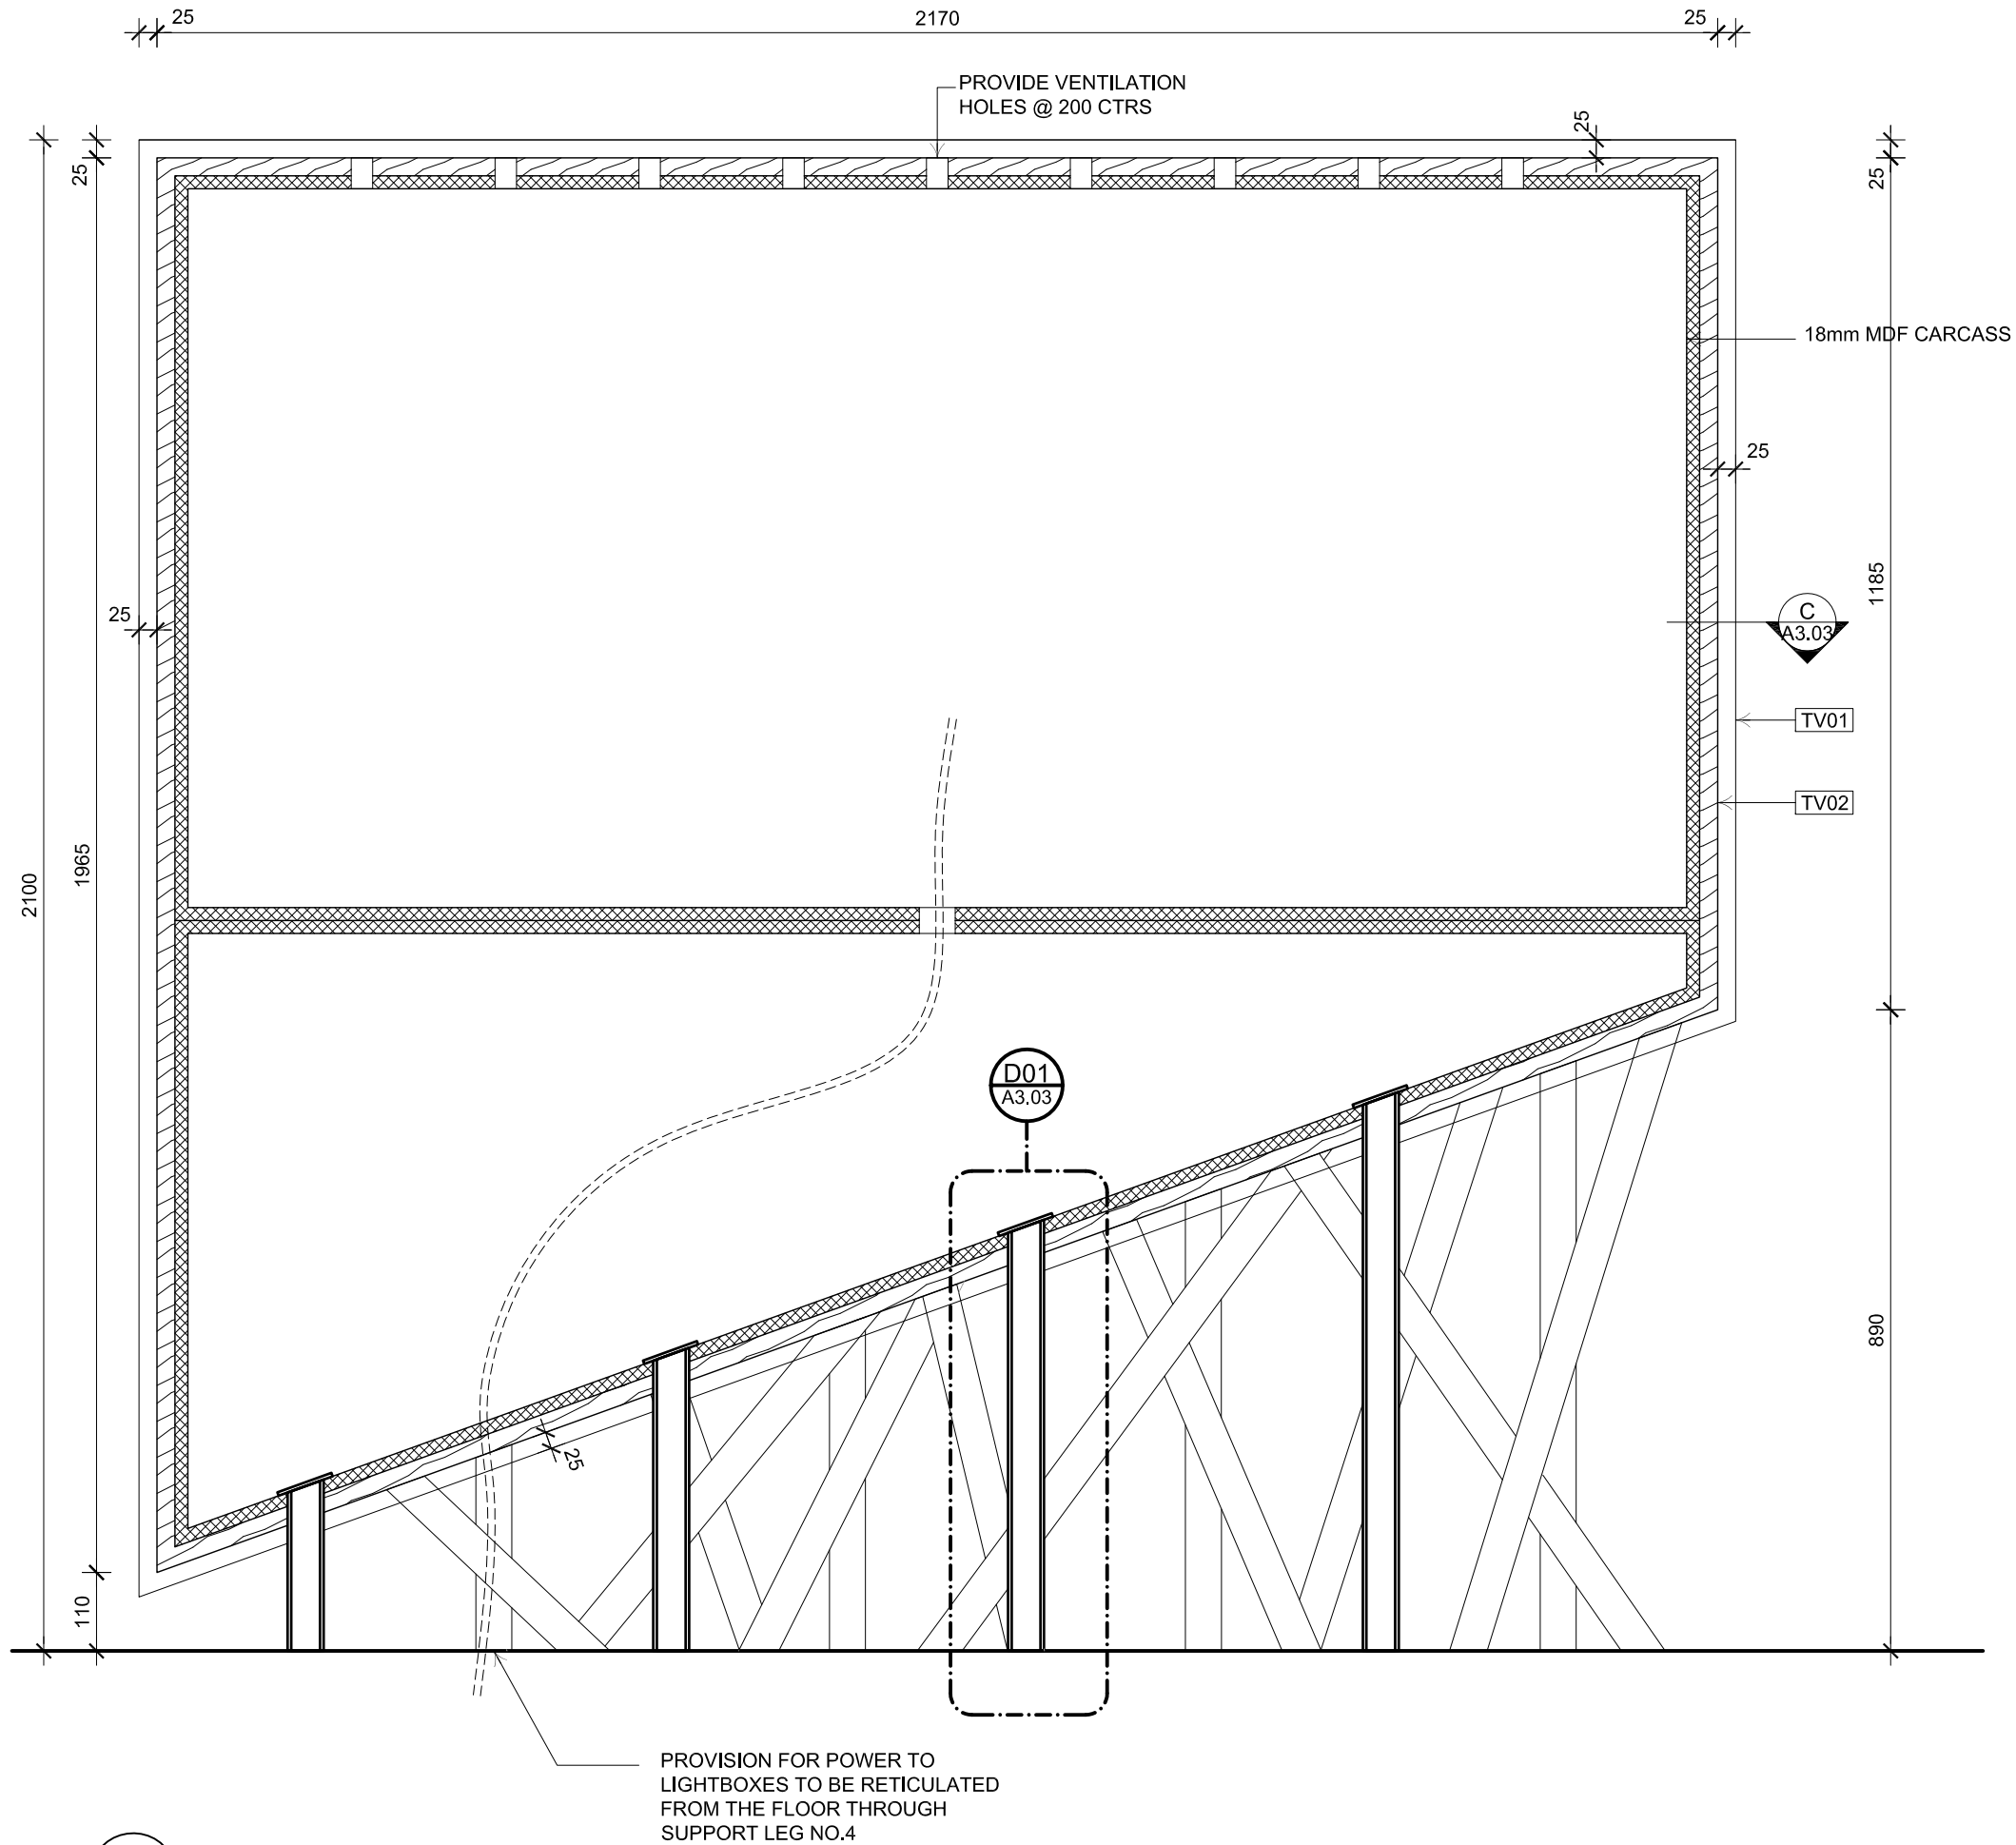

AA SECTION
A3.01 1:10

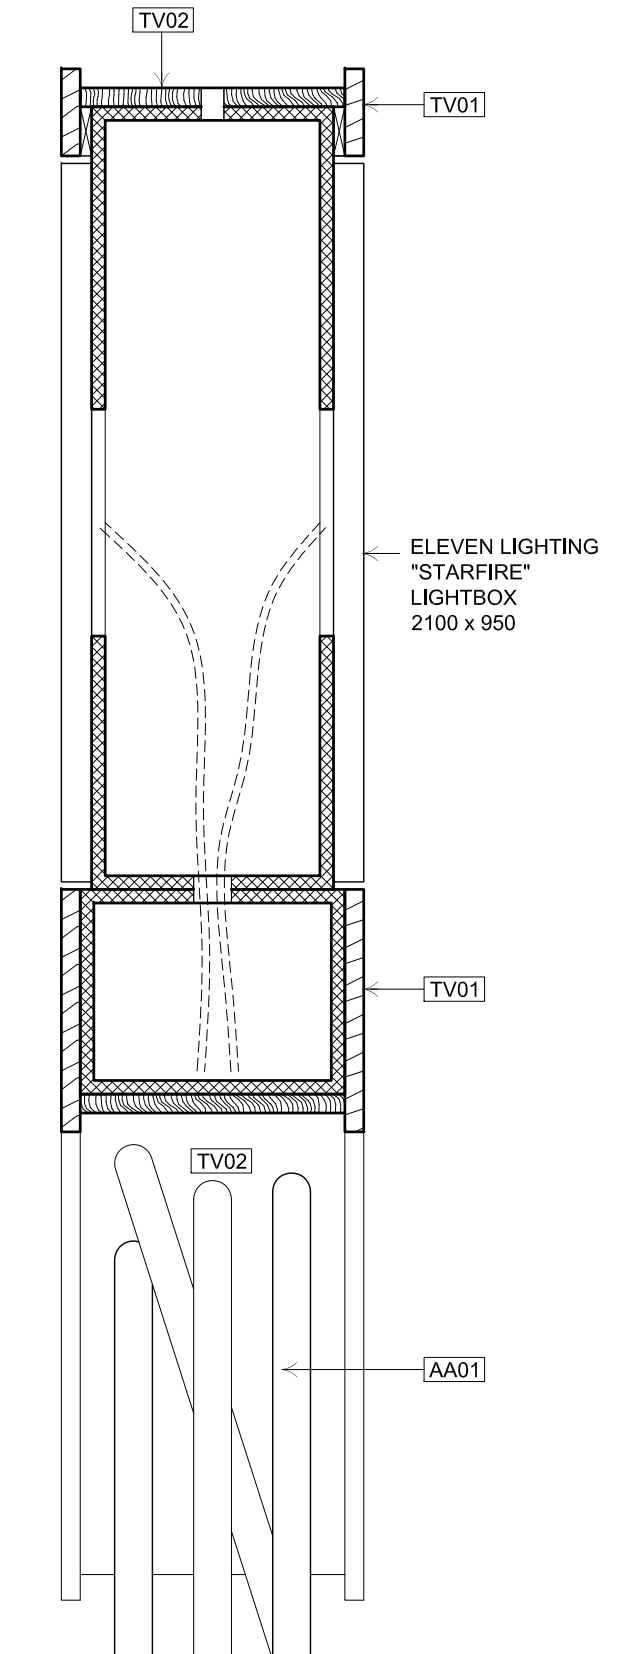

BB SECTION
A3.02 1:10

DESIGNERS

CMD
Cunningham Martyn Design P.L.
18 Willis Street Richmond
Victoria 3121 Australia
Telephone 03 9428 2777
Facsimile 03 9428 2312
E-mail office@cmdesign.com.au
ACN 067 622 315

CONSULTANTS

REVISIONS

DATE	REV NO.	DETAILS
15.11.07	T1	FOR TENDER

CLIENT

MELBOURNE WATER

PROJECT

EDITHVALE-SEAFORD WETLANDS
DISCOVERY CENTRE

DRAWING TITLE

JOINERY UNIT 1
SHEET 2

DATE

NOV. 07

DRAWN BY

CT

AS SHOWN @A3

EW 7199

ALL DIMENSIONS IN MILLIMETRES. WORK TO
FIGURED DIMENSIONS ONLY. DO NOT USE
SCALED DIMENSIONS. CHECK ALL DIMENSIONS ON
SITE AND REPORT ALL DISCREPANCIES TO THE
DESIGNERS BEFORE PROCEEDING WITH WORK.

DRAWING NUMBER


A3.02

CAD FILE


ISSUE

-


T1

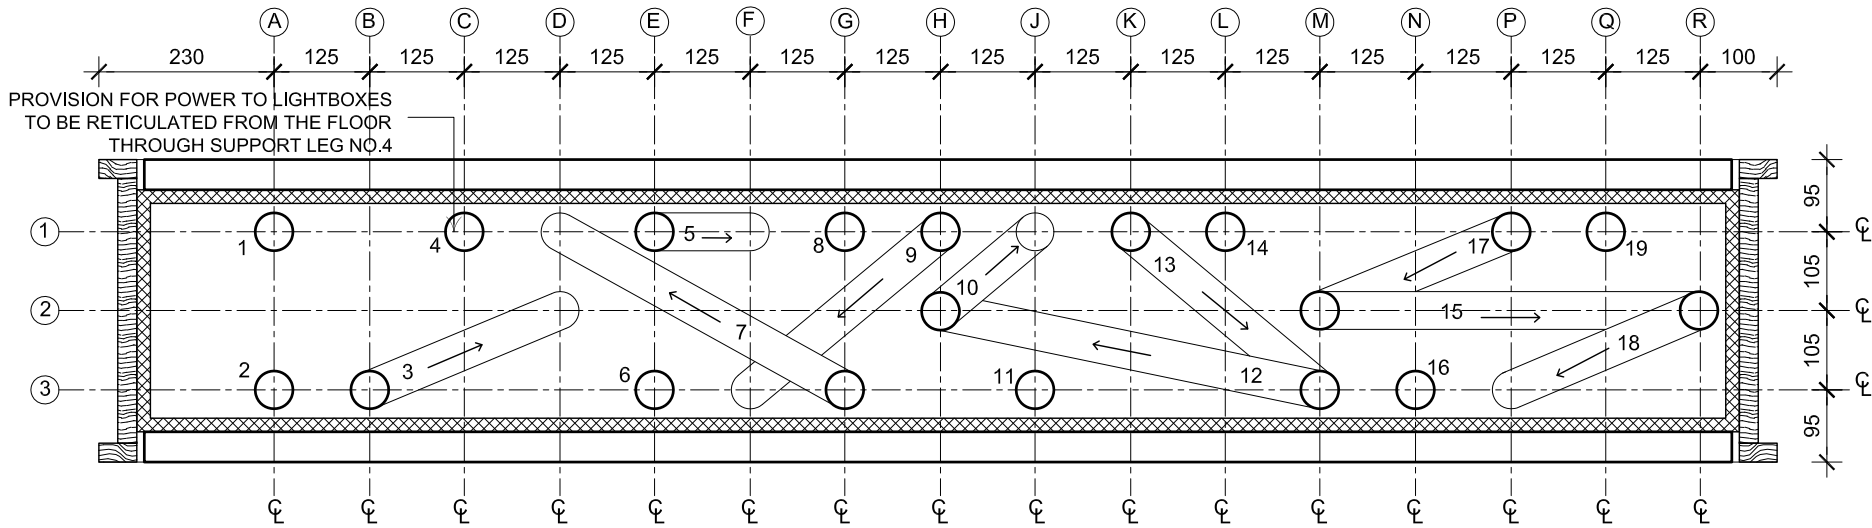

01 ANGLED LEG SETOUT PLAN
- 1:10

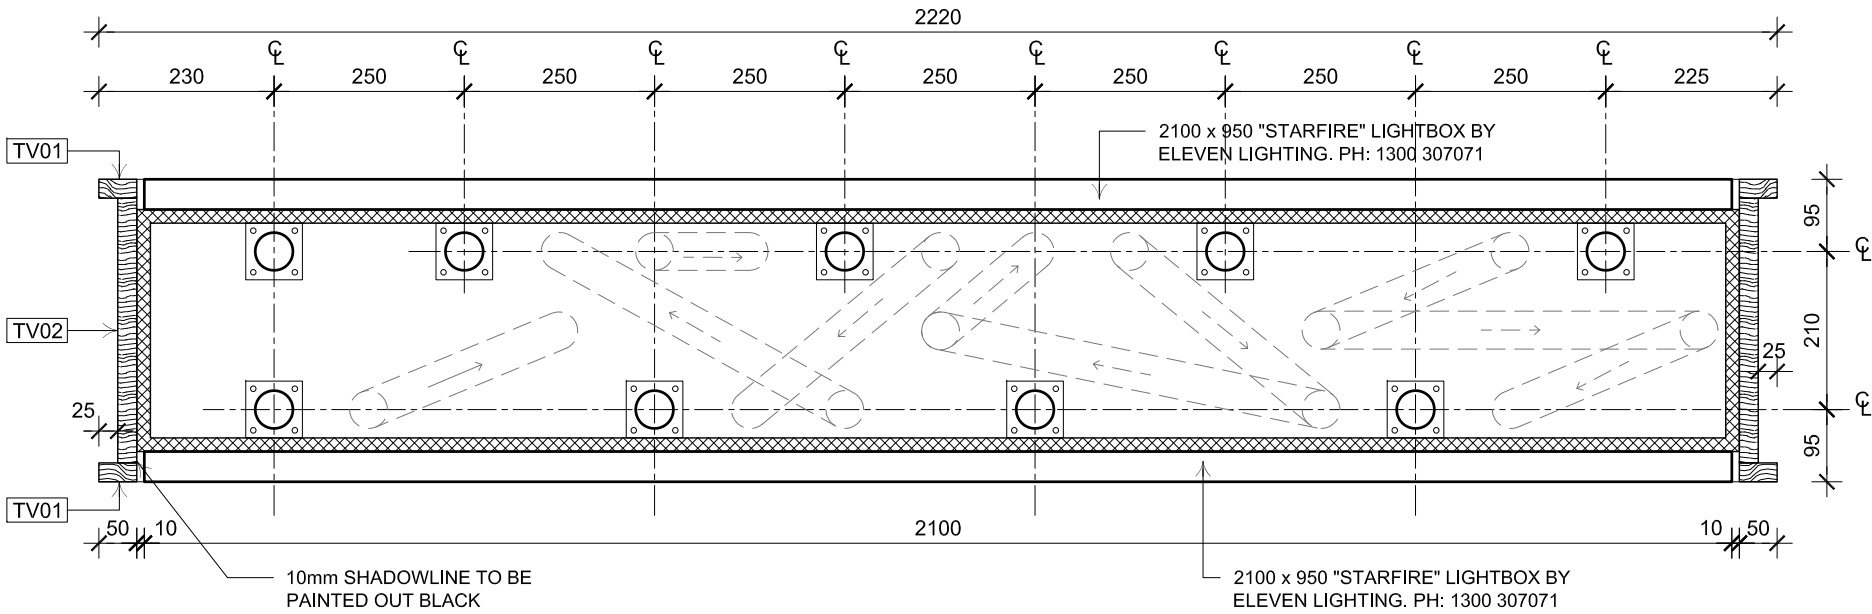


CC SECTION
A3.02 1:10

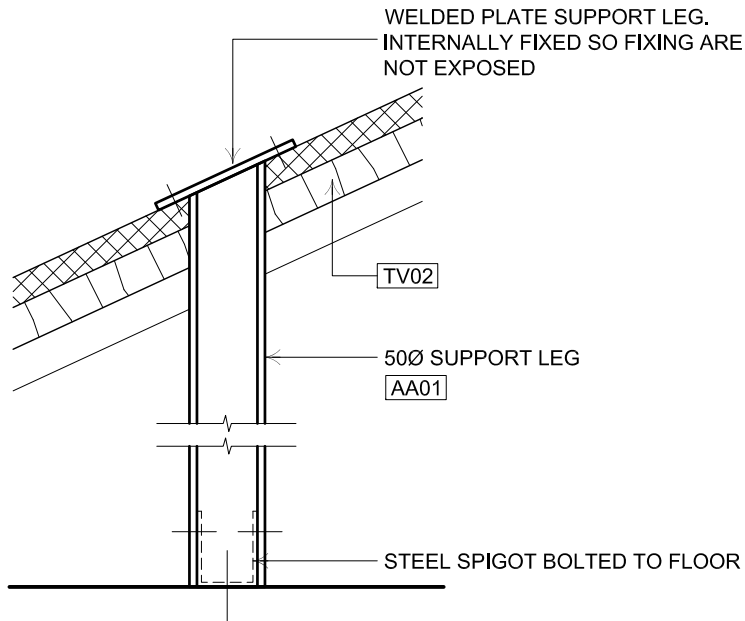


D01 DETAIL
A3.02 1:10


SUPPORT LEG SCHEDULE		
LEG	TOP GRID	BOTTOM GRID
1	A,1	A,1
2	A,3	A,3
3	B,3	D,2
4	C,1	C,1
5	E,1	F,1
6	E,3	E,3
7	G,3	D,1
8	G,1	G,1
9	H,1	F,3
10	H,,2	J,1
11	J,3	J,3
12	M,3	H,2
13	K,1	M,3
14	L,1	L,1
15	M,2	R,2
16	N,3	N,3
17	P,1	M,2
18	R,2	P,3
19	Q,1	Q,1

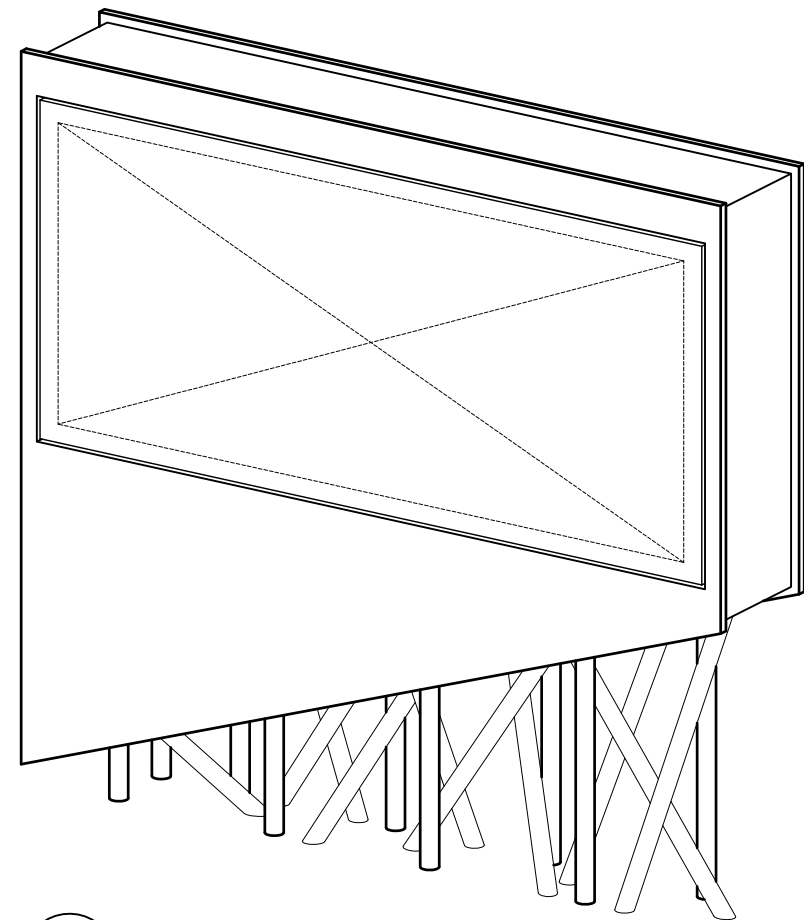


02 ISOMETRIC VIEW
- 1:10

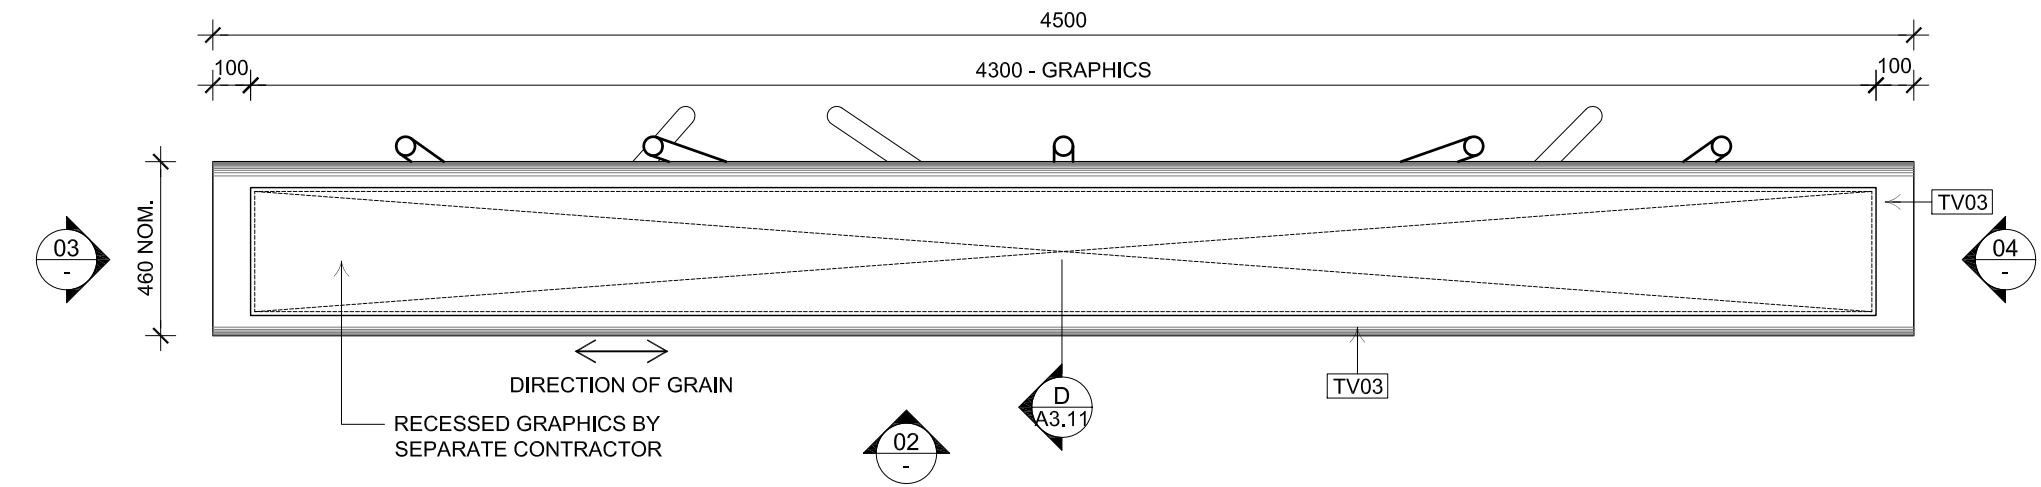

01 PLAN
1:20

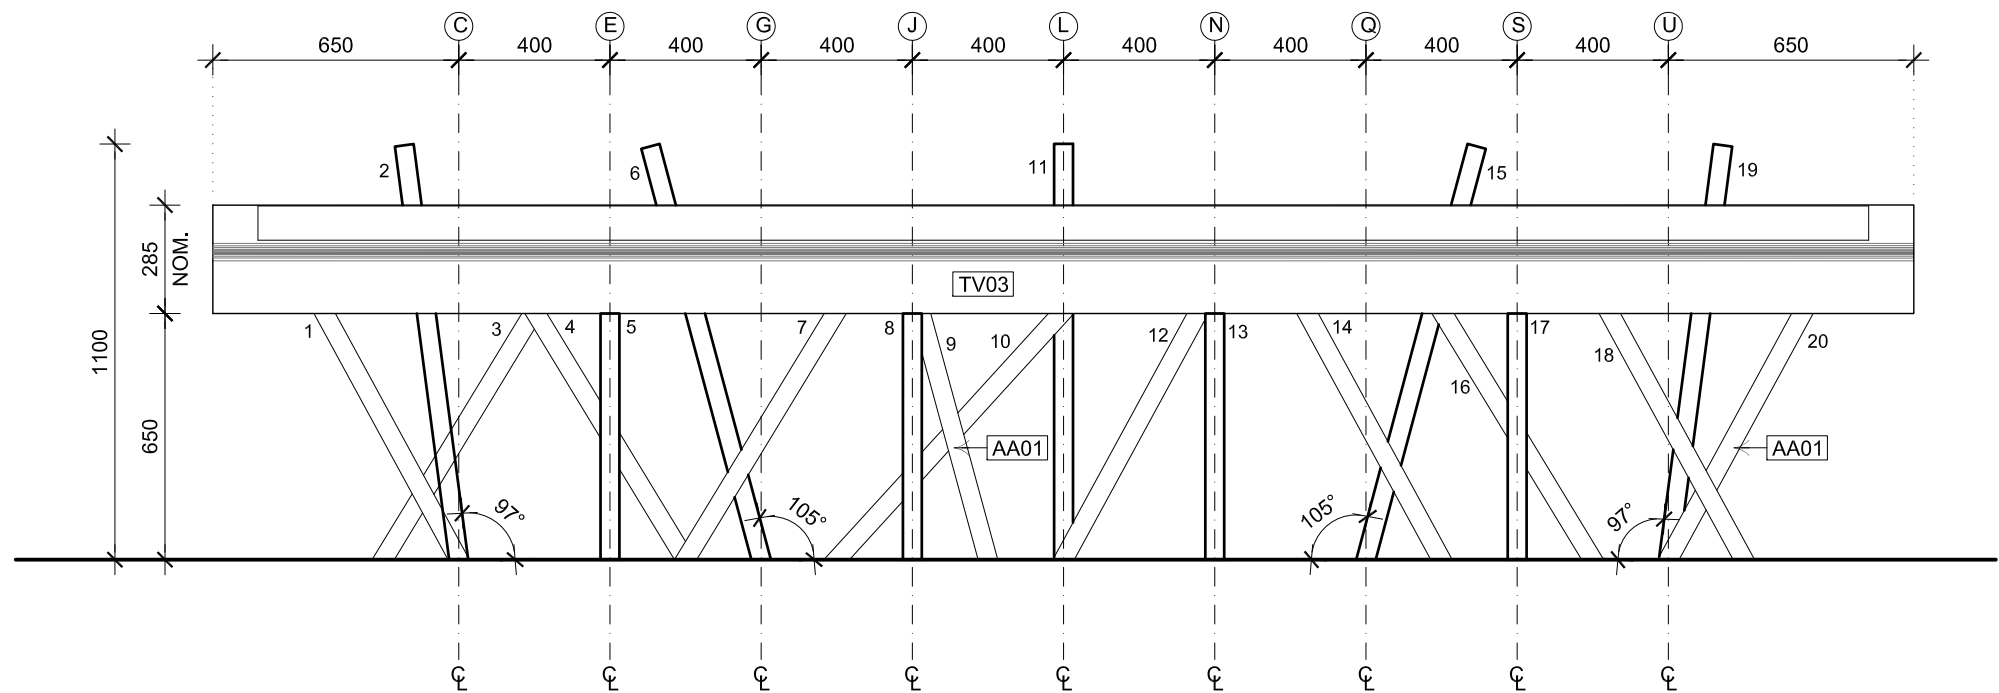

02 FRONT ELEVATION
1:20

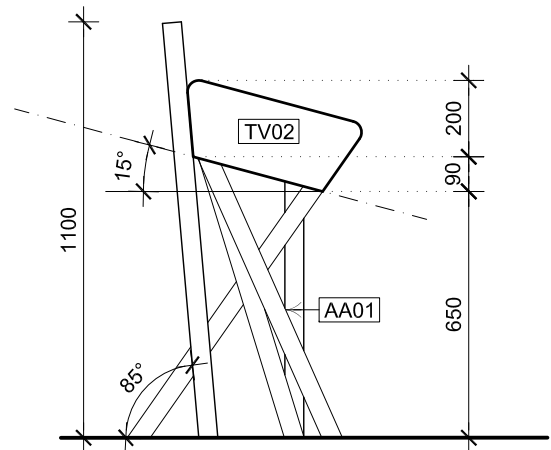

03&04 SIDE ELEVATION
1:20

DESIGNERS

CMD
Cunningham Martyn Design P.L.
18 Willis Street Richmond
Victoria 3121 Australia
Telephone 03 9428 2777
Facsimile 03 9428 2312
E-mail office@cmdesign.com.au
ACN 067 622 315

CONSULTANTS

REVISIONS		
DATE	REV NO.	DETAILS
15.11.07	T1	FOR TENDER

CLIENT
MELBOURNE WATER

PROJECT
EDITHVALE-SEAFORD WETLANDS
DISCOVERY CENTRE

DRAWING TITLE
JOINERY UNIT 2
SHEET 1


DATE	DRAWN BY
NOV. 07	CT
	JOB NUMBER
AS SHOWN @A3	EW 7199

ALL DIMENSIONS IN MILLIMETRES. WORK TO FIGURED DIMENSIONS ONLY. DO NOT USE SCALED DIMENSIONS. CHECK ALL DIMENSIONS ON SITE AND REPORT ALL DISCREPANCIES TO THE DESIGNERS BEFORE PROCEEDING WITH WORK.

DRAWING NUMBER

A3.10


CAD FILE	ISSUE
-	T1

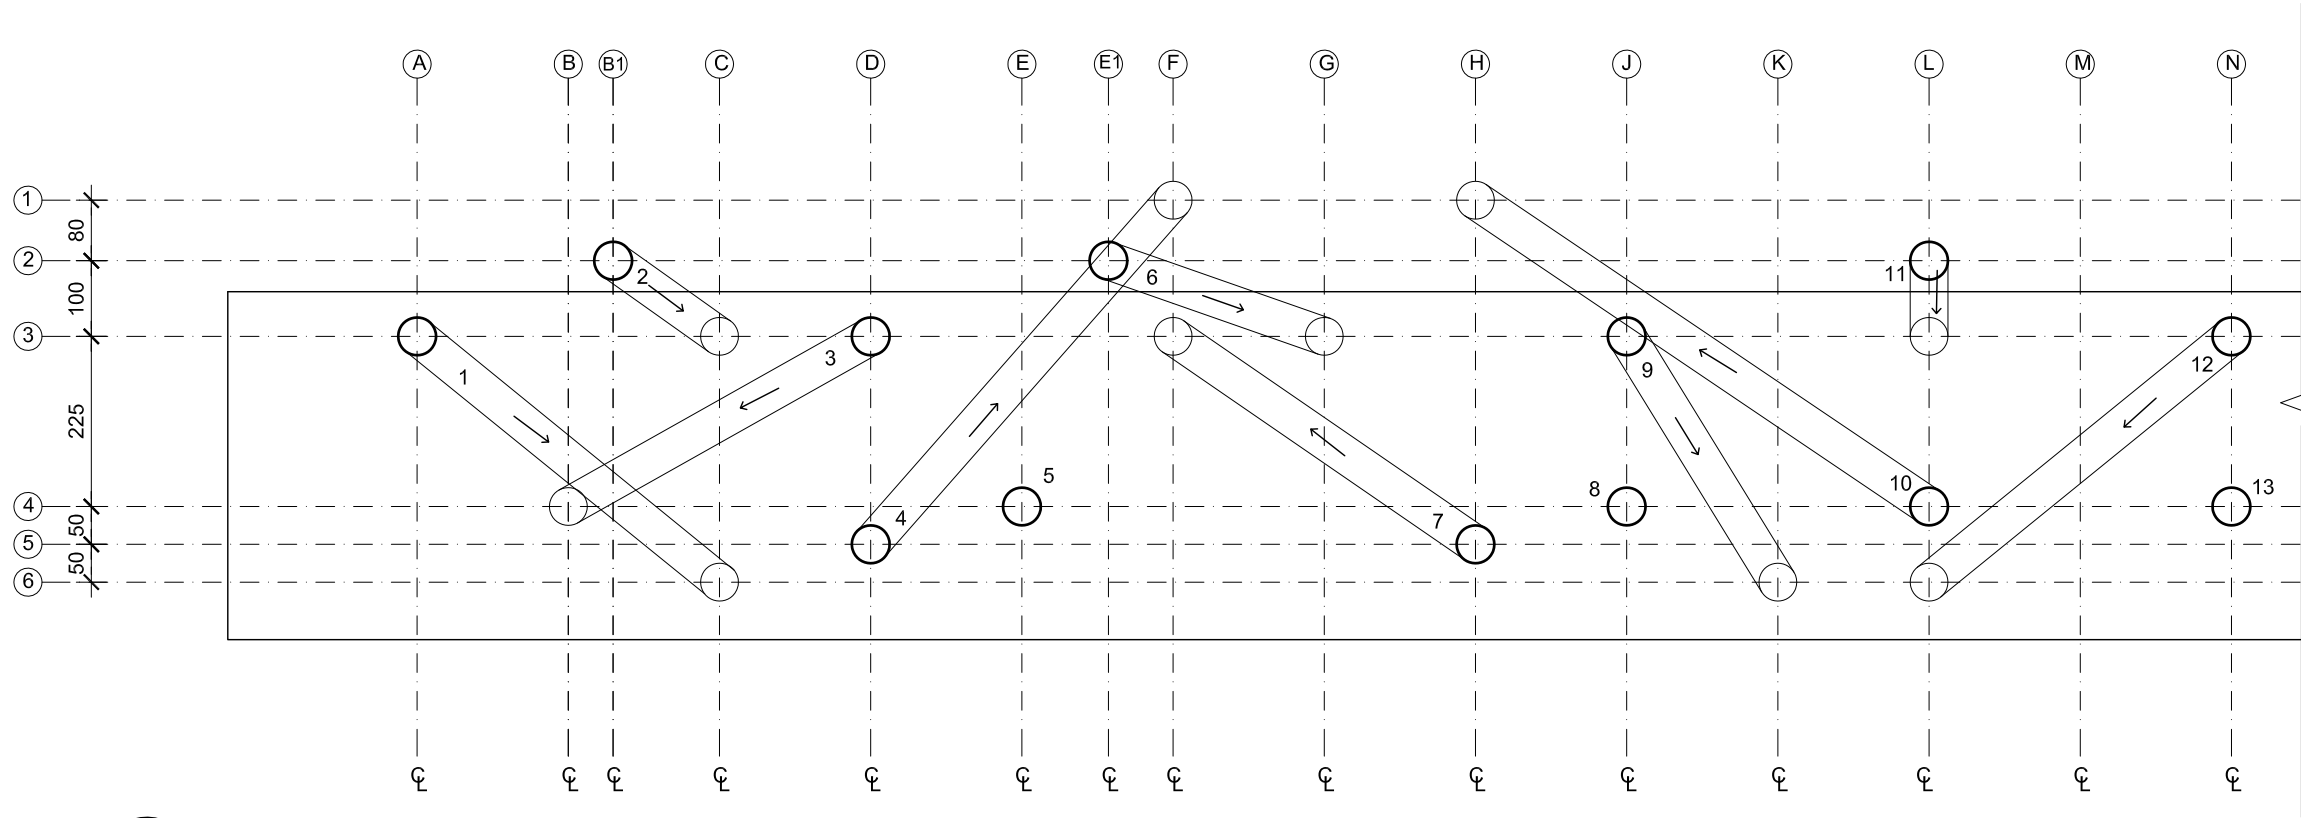


SUPPORT LEG SCHEDULE

LEG	TOP GRID	BOTTOM GRID
1	A,3	C,6
2	B1,2	C,3
3	D,3	B,4
4	D,5	F,1
5	E,4	E,4
6	E1,2	G,3
7	H,5	F,3
8	J,4	J,4
9	J,3	K,6
10	L,4	H,1
11	L,2	L,3
12	N,3	L,6
13	N,4	N,4
14	P,3	R,6
15	R1,2	Q,3
16	R,4	T,1
17	S,4	S,4
18	T,3	V,6
19	U1,2	U,3
20	X,3	U,4

01 ANGLED LEG SETOUT PLAN - PART 1
- 1:10

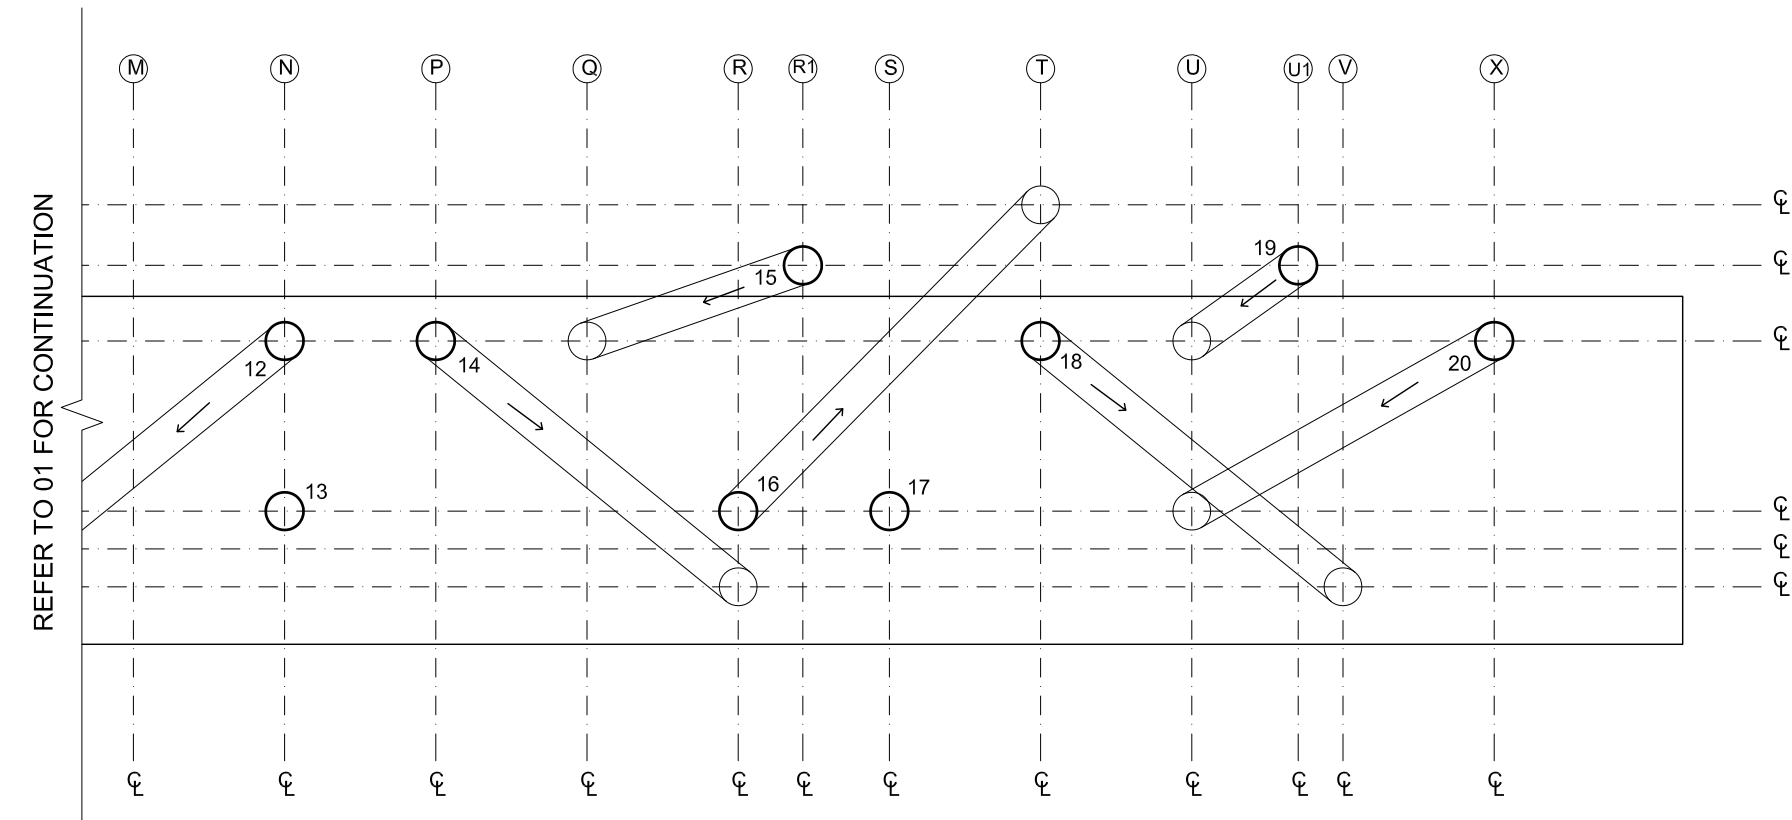

02 ANGLED LEG SETOUT PLAN - PART 2
- 1:10

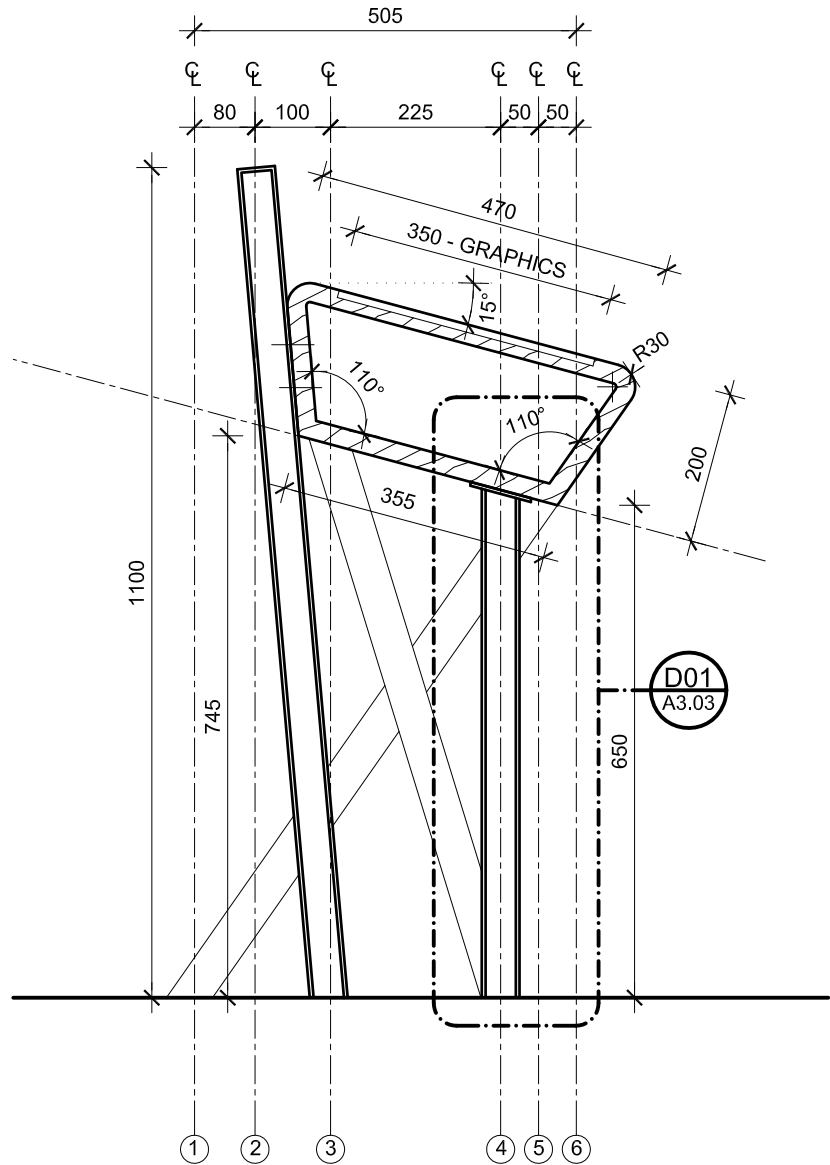

DD SECTION
A3.10 1:10

DESIGNERS

CMD

Cunningham Martyn Design P.L.
18 Willis Street Richmond
Victoria 3121 Australia
Telephone 03 9428 2777
Facsimile 03 9428 2312
E-mail office@cmdesign.com.au
ACN 067 622 315

CONSULTANTS

REVISIONS

DATE	REV NO.	DETAILS
15.11.07	T1	FOR TENDER

CLIENT

MELBOURNE WATER

PROJECT

EDITHVALE-SEAFORD WETLANDS
DISCOVERY CENTRE

DRAWING TITLE

JOINERY UNIT 2
SHEET 2


DATE	DRAWN BY
NOV. 07	CT
	JOB NUMBER
AS SHOWN @A3	EW 7199

ALL DIMENSIONS IN MILLIMETRES. WORK TO FIGURED DIMENSIONS ONLY. DO NOT USE SCALED DIMENSIONS. CHECK ALL DIMENSIONS ON SITE AND REPORT ALL DISCREPANCIES TO THE DESIGNERS BEFORE PROCEEDING WITH WORK.


DRAWING NUMBER

A3.11


CAD FILE	ISSUE
-	T1

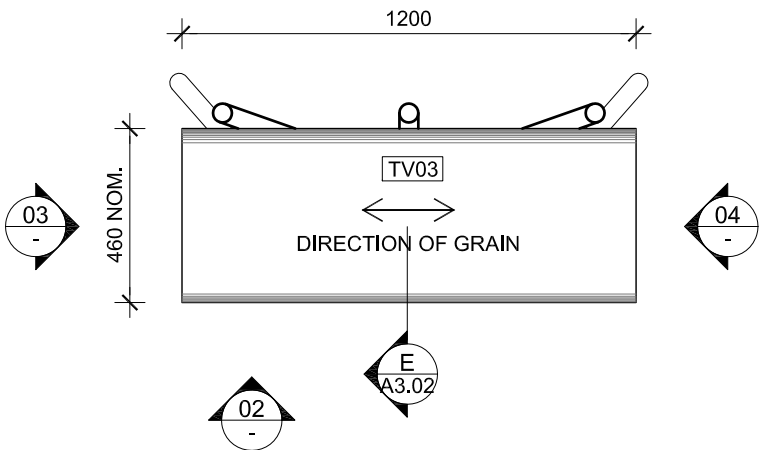


01 PLAN (BIRD WATCHING TABLE)
- 1:20

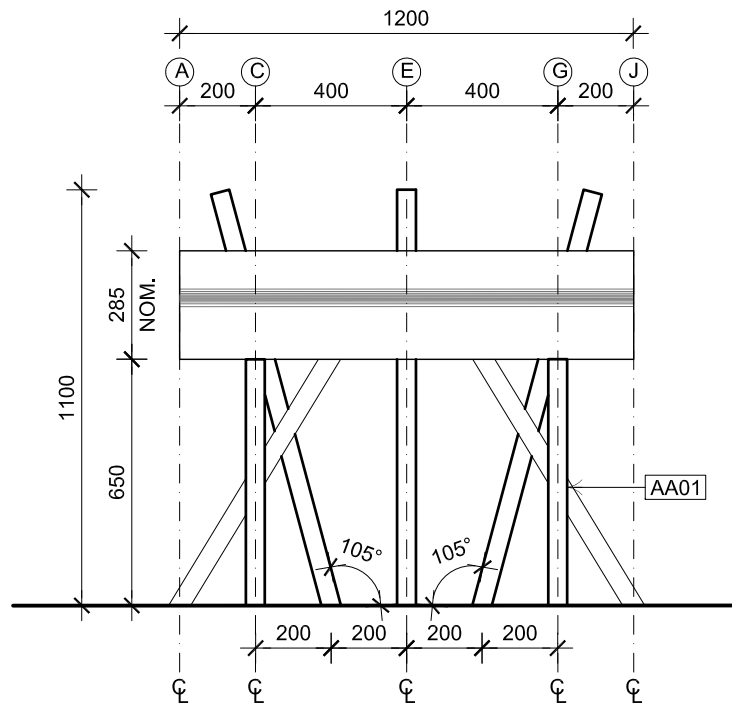

02 FRONT ELEVATION
- 1:20

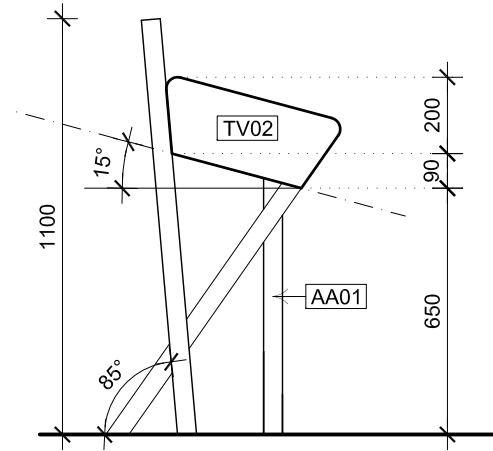


03&04 SIDE ELEVATION
- 1:20

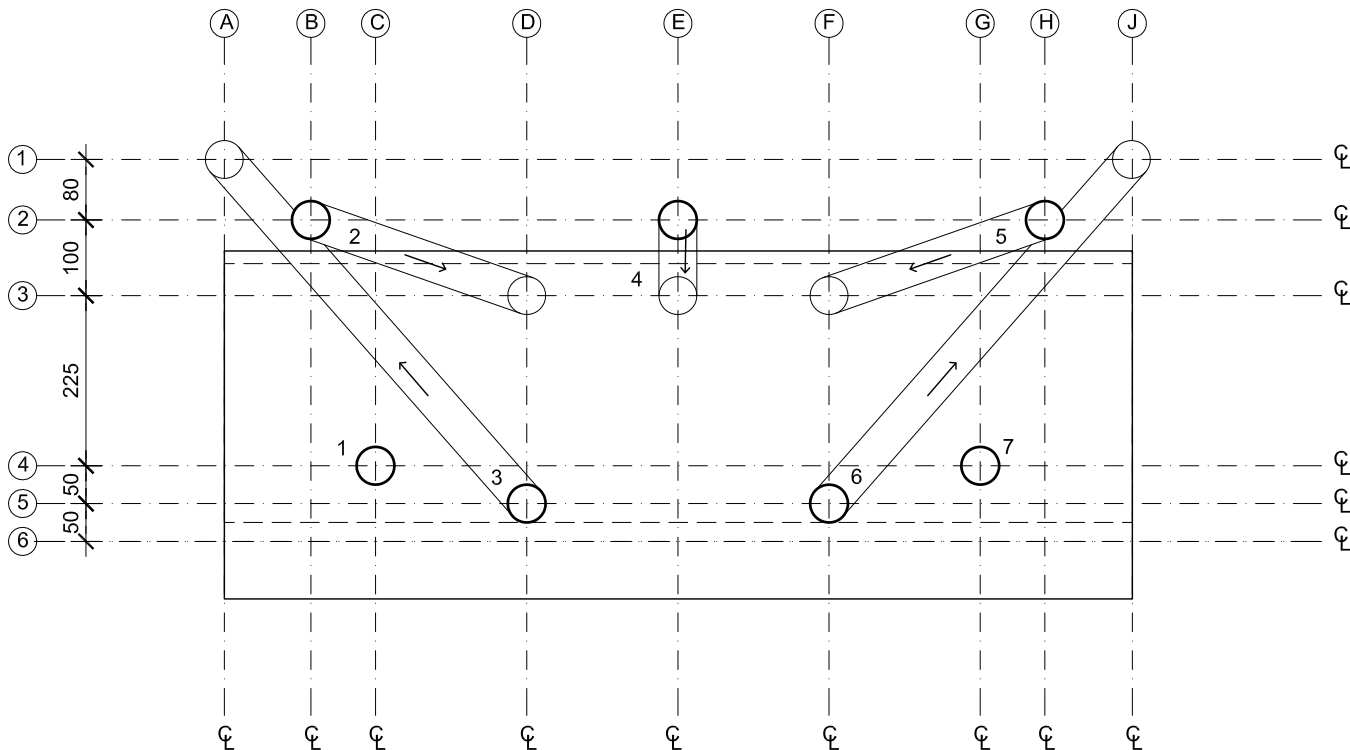

05 ANGLED LEG SETOUT PLAN
- 1:10

SUPPORT LEG SCHEDULE

LEG	TOP GRID	BOTTOM GRID
1	C,4	C,4
2	B,2	D,3
3	D,5	A,1
4	E,2	E,3
5	H,2	F,3
6	F,5	J,1
7	G,4	G,4

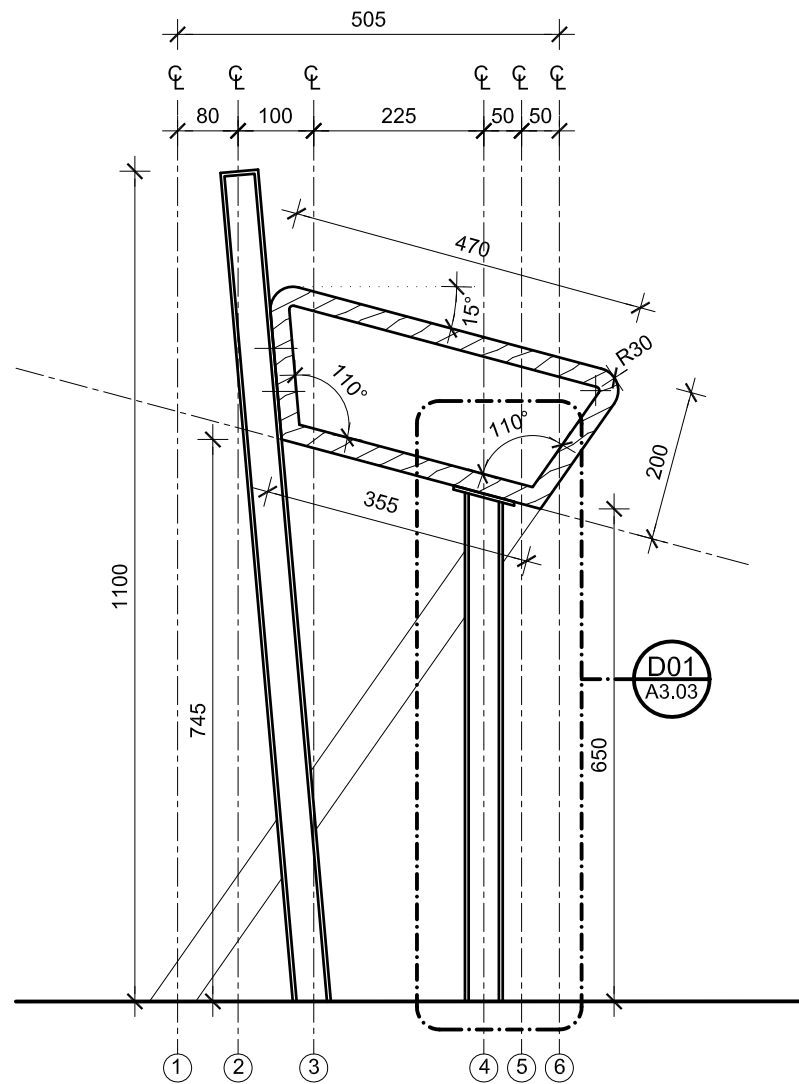

EE SECTION
- 1:10

DESIGNERS

CMD
Cunningham Martyn Design P.L.
18 Willis Street Richmond
Victoria 3121 Australia
Telephone 03 9428 2777
Facsimile 03 9428 2312
E-mail office@cmdesign.com.au
ACN 067 622 315

CONSULTANTS

REVISIONS

DATE	REV NO.	DETAILS
15.11.07	T1	FOR TENDER

CLIENT

MELBOURNE WATER

PROJECT

EDITHVALE-SEAFORD WETLANDS
DISCOVERY CENTRE

DRAWING TITLE

BIRD WATCHING TABLE
SHEET 1

DATE

NOV. 07

DRAWN BY

CT

JOB NUMBER

AS SHOWN @A3

EW 7199

ALL DIMENSIONS IN MILLIMETRES. WORK TO
FIGURED DIMENSIONS ONLY. DO NOT USE
SCALED DIMENSIONS. CHECK ALL DIMENSIONS ON
SITE AND REPORT ALL DISCREPANCIES TO THE
DESIGNERS BEFORE PROCEEDING WITH WORK.

DRAWING NUMBER


A3.20

CAD FILE


-

ISSUE


T1

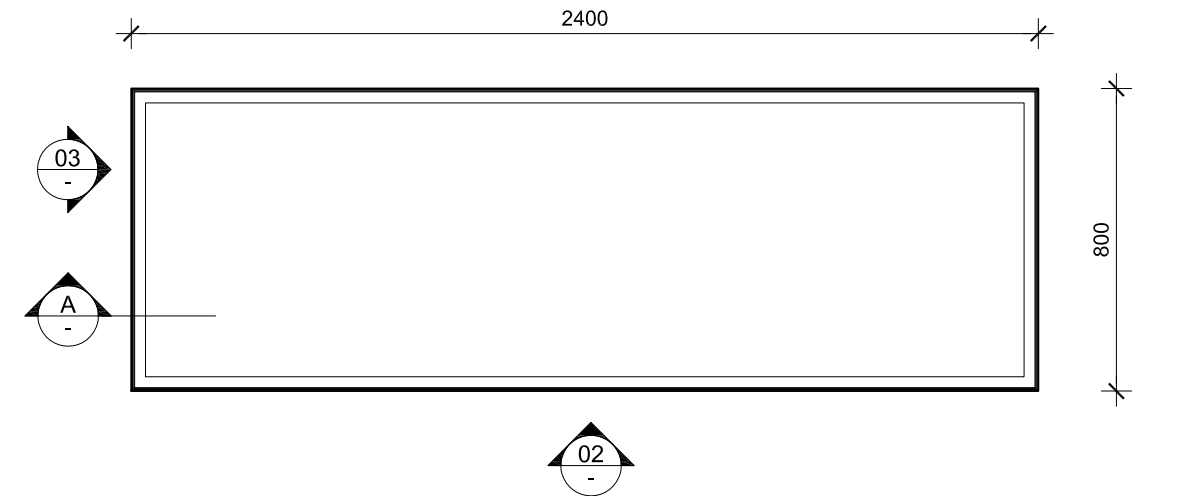


01 SHOWCASE SC A-04 PLAN
1:20

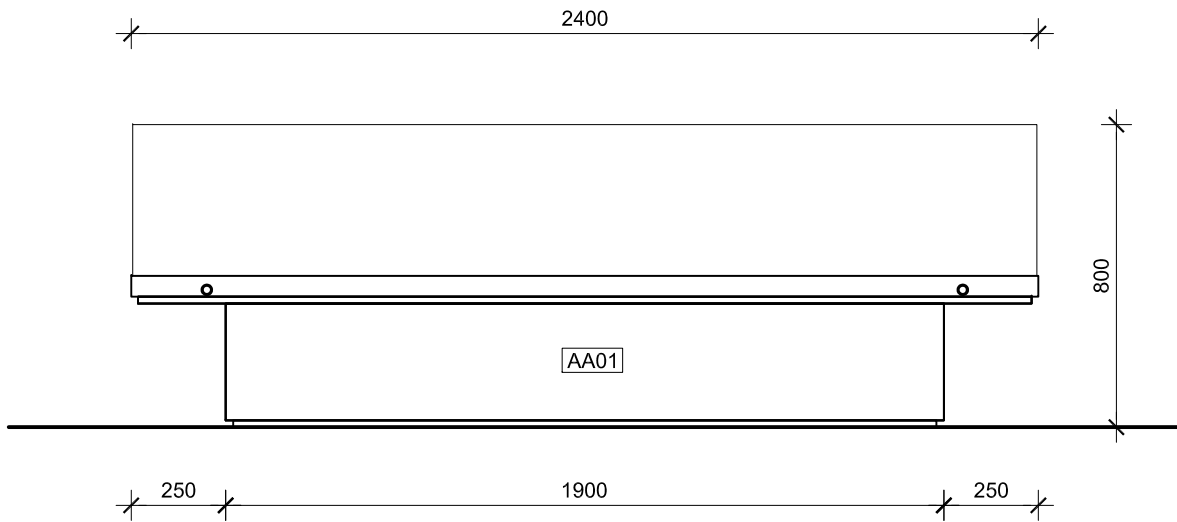

02 ELEVATION
1:20

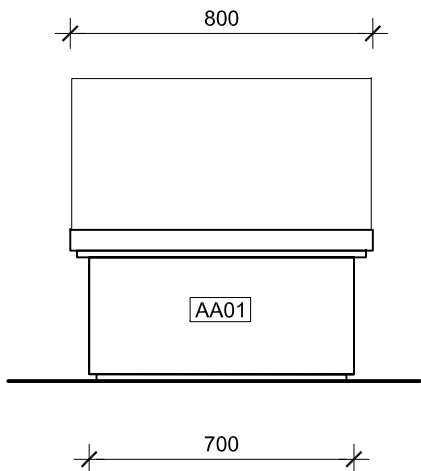

03 ELEVATION
1:20

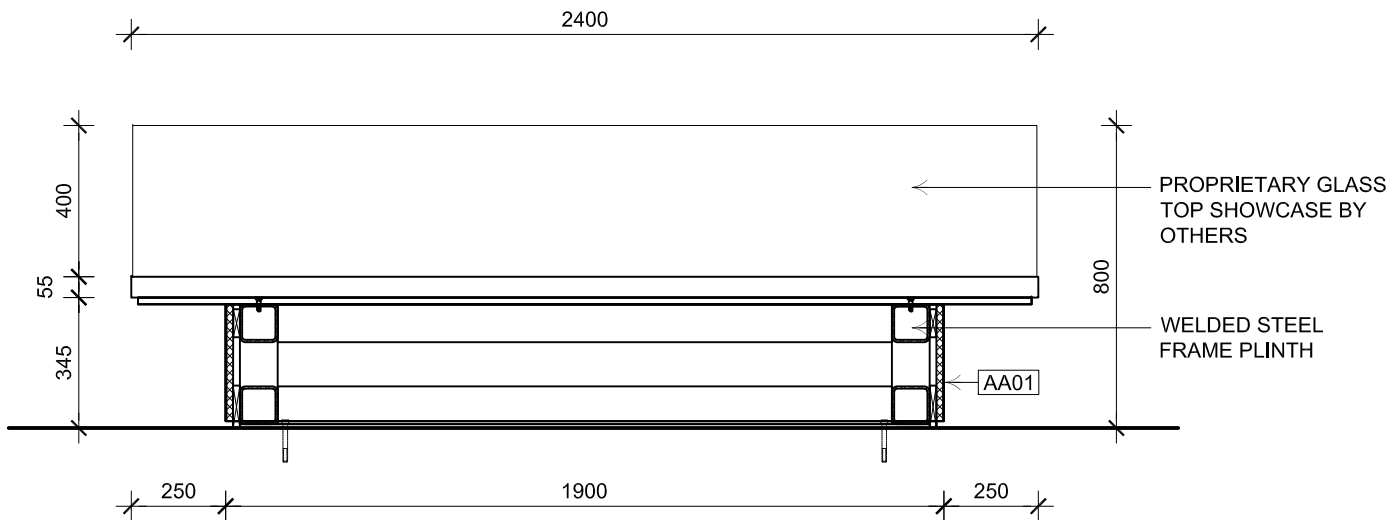

AA SECTION
1:20

DESIGNERS

CMD
Cunningham Martyn Design P.L.
18 Willis Street Richmond
Victoria 3121 Australia
Telephone 03 9428 2777
Facsimile 03 9428 2312
E-mail office@cmdesign.com.au
ACN 067 622 315

CONSULTANTS

REVISIONS

DATE	REV NO.	DETAILS
15.11.07	T1	FOR TENDER

CLIENT

MELBOURNE WATER

PROJECT

EDITHVALE-SEAFORD WETLANDS
DISCOVERY CENTRE

DRAWING TITLE

TOUCH TABLE
SHEET 1

DATE

NOV. 07

DRAWN BY

CT

JOB NUMBER

AS SHOWN @A3 EW 7199

ALL DIMENSIONS IN MILLIMETRES. WORK TO
FIGURED DIMENSIONS ONLY. DO NOT USE
SCALED DIMENSIONS. CHECK ALL DIMENSIONS ON
SITE AND REPORT ALL DISCREPANCIES TO THE
DESIGNERS BEFORE PROCEEDING WITH WORK.

DRAWING NUMBER


A3.30

CAD FILE


-

ISSUE


T1

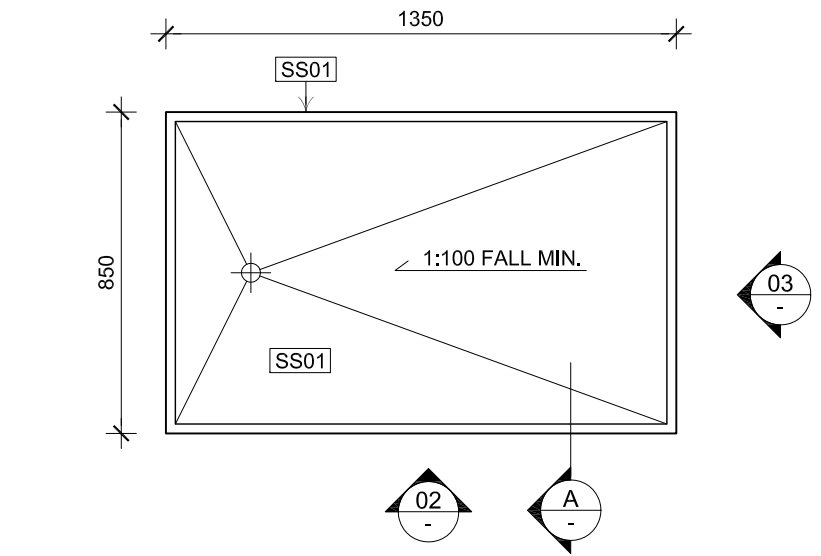


01 TOUCH TABLE PLAN
1:20

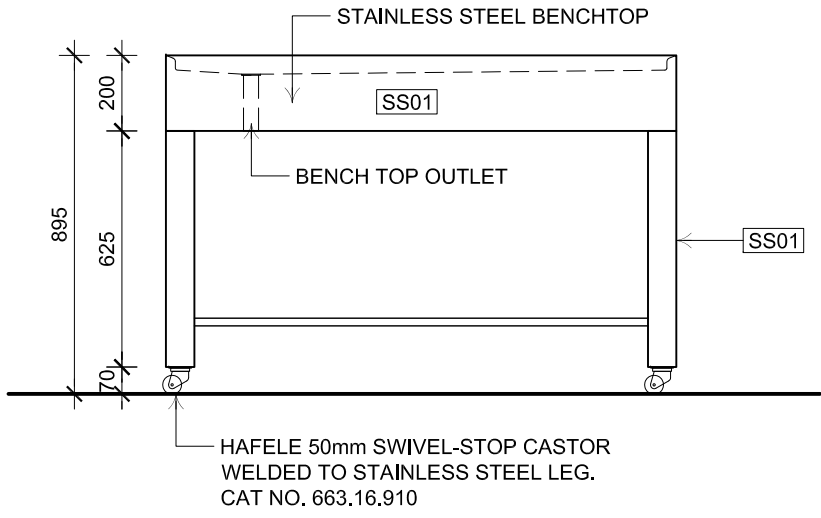

02 ELEVATION
1:20

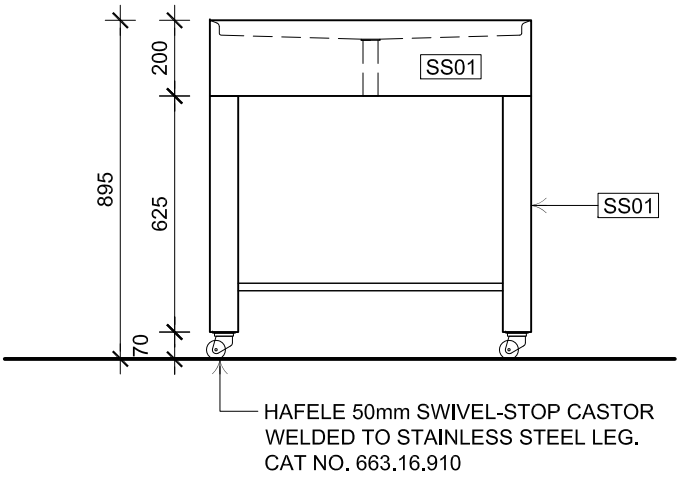

03 ELEVATION
1:20

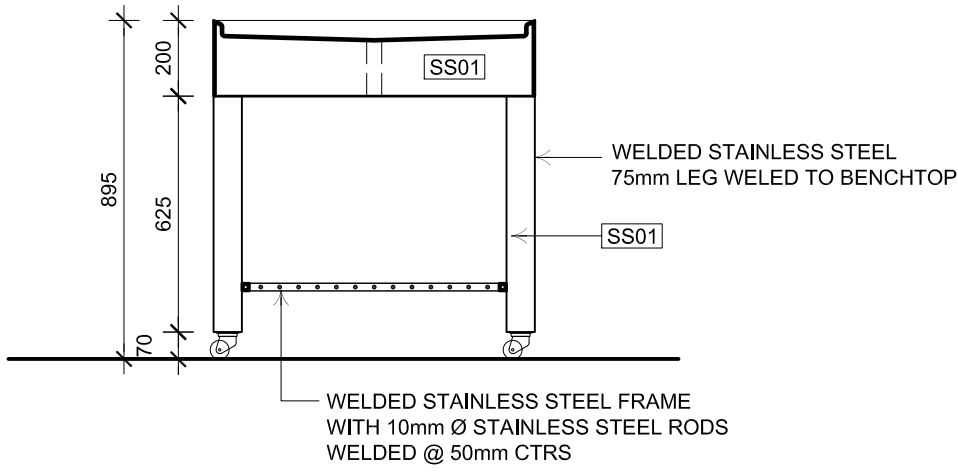

AA SECTION
1:20

DESIGNERS

CMD
Cunningham Martyn Design P.L.
18 Willis Street Richmond
Victoria 3121 Australia
Telephone 03 9428 2777
Facsimile 03 9428 2312
E-mail office@cmdesign.com.au
ACN 067 622 315

CONSULTANTS

REVISIONS		
DATE	REV NO.	DETAILS
15.11.07	T1	FOR TENDER

CLIENT
MELBOURNE WATER

PROJECT
EDITHVALE-SEAFORD WETLANDS
DISCOVERY CENTRE

DRAWING TITLE
TOUCH TABLE
SHEET 1

DATE	DRAWN BY
NOV. 07	CT
	JOB NUMBER
AS SHOWN @A3	EW 7199

ALL DIMENSIONS IN MILLIMETRES. WORK TO
FIGURED DIMENSIONS ONLY. DO NOT USE
SCALED DIMENSIONS. CHECK ALL DIMENSIONS ON
SITE AND REPORT ALL DISCREPANCIES TO THE
DESIGNERS BEFORE PROCEEDING WITH WORK.

DRAWING NUMBER

A3.50

CAD FILE	ISSUE
-	T1